




NOTE: THESE PLANS ARE NOT DETAILED DOCUMENTS THAT OUTLINE AND DELINEATE ALL ACCEPTED CONSTRUCTION PRACTICES. THE BUILDER MUST HAVE THE FIELD EXPERIENCE AND ABILITY TO SOLVE BUILDING ISSUES AND CONFLICTS. ALL SUBCONTRACTORS SHOULD BE PROFICIENT IN THEIR ABILITY TO INTERPRET PLANS, UNDERSTAND AND FOLLOW CODE REQUIREMENTS AND ACCEPTABLE CONSTRUCTION PRACTICES IN THE CONSTRUCTION PROCESS.

LCJ DESIGN LLC. IS NOT RESPONSIBLE FOR ANY CONSTRUCTION ISSUES NOT DISCUSSED PRIOR TO BEGINNING CONSTRUCTION. DISCOVERY OF ANY, ERRORS OR OMISSIONS IN THESE DOCUMENTS ARE TO BE BROUGHT TO THE IMMEDIATE ATTENTION OF LCJ DESIGN LLC. PRIOR TO ANY CONSTRUCTION WORK OR PURCHASES. ALL DIMENSIONS AND CLEARANCES TO BE VERIFIED BY OWNER/CONTRACTOR PRIOR TO BEGINNING ANY CONSTRUCTION. LCJ DESIGN LLC. IS NOT RESPONSIBLE FOR ANY CONSTRUCTION ISSUES WHICH MAY ARISE DURING OR AFTER THE CONSTRUCTION OF THIS BUILDING. THERE ARE NO GUARANTEES OR WARRANTIES SPECIFIC OR IMPLIED ASSOCIATED WITH THESE DESIGN DOCUMENTS.

"The Shawnee"

3Bdrm 2 Bath Trey Ceiling

DESIGN, LLC. LCJ Design 5526 N Cleveland Street Dayton, Texas 77535 PHONE: 936-402-2166 FAX: 936-402-2166 MOBILE: 639-402-2166 jdbrown@lcjdesign.net		All Services Consulting	
		PHONE: _____ FAX: _____ MOBILE: _____	DRAWN BY: _____ SCALE: As Noted DATE: Saturday, October 9, 2021
		PAGE: 1/11 3D Images	

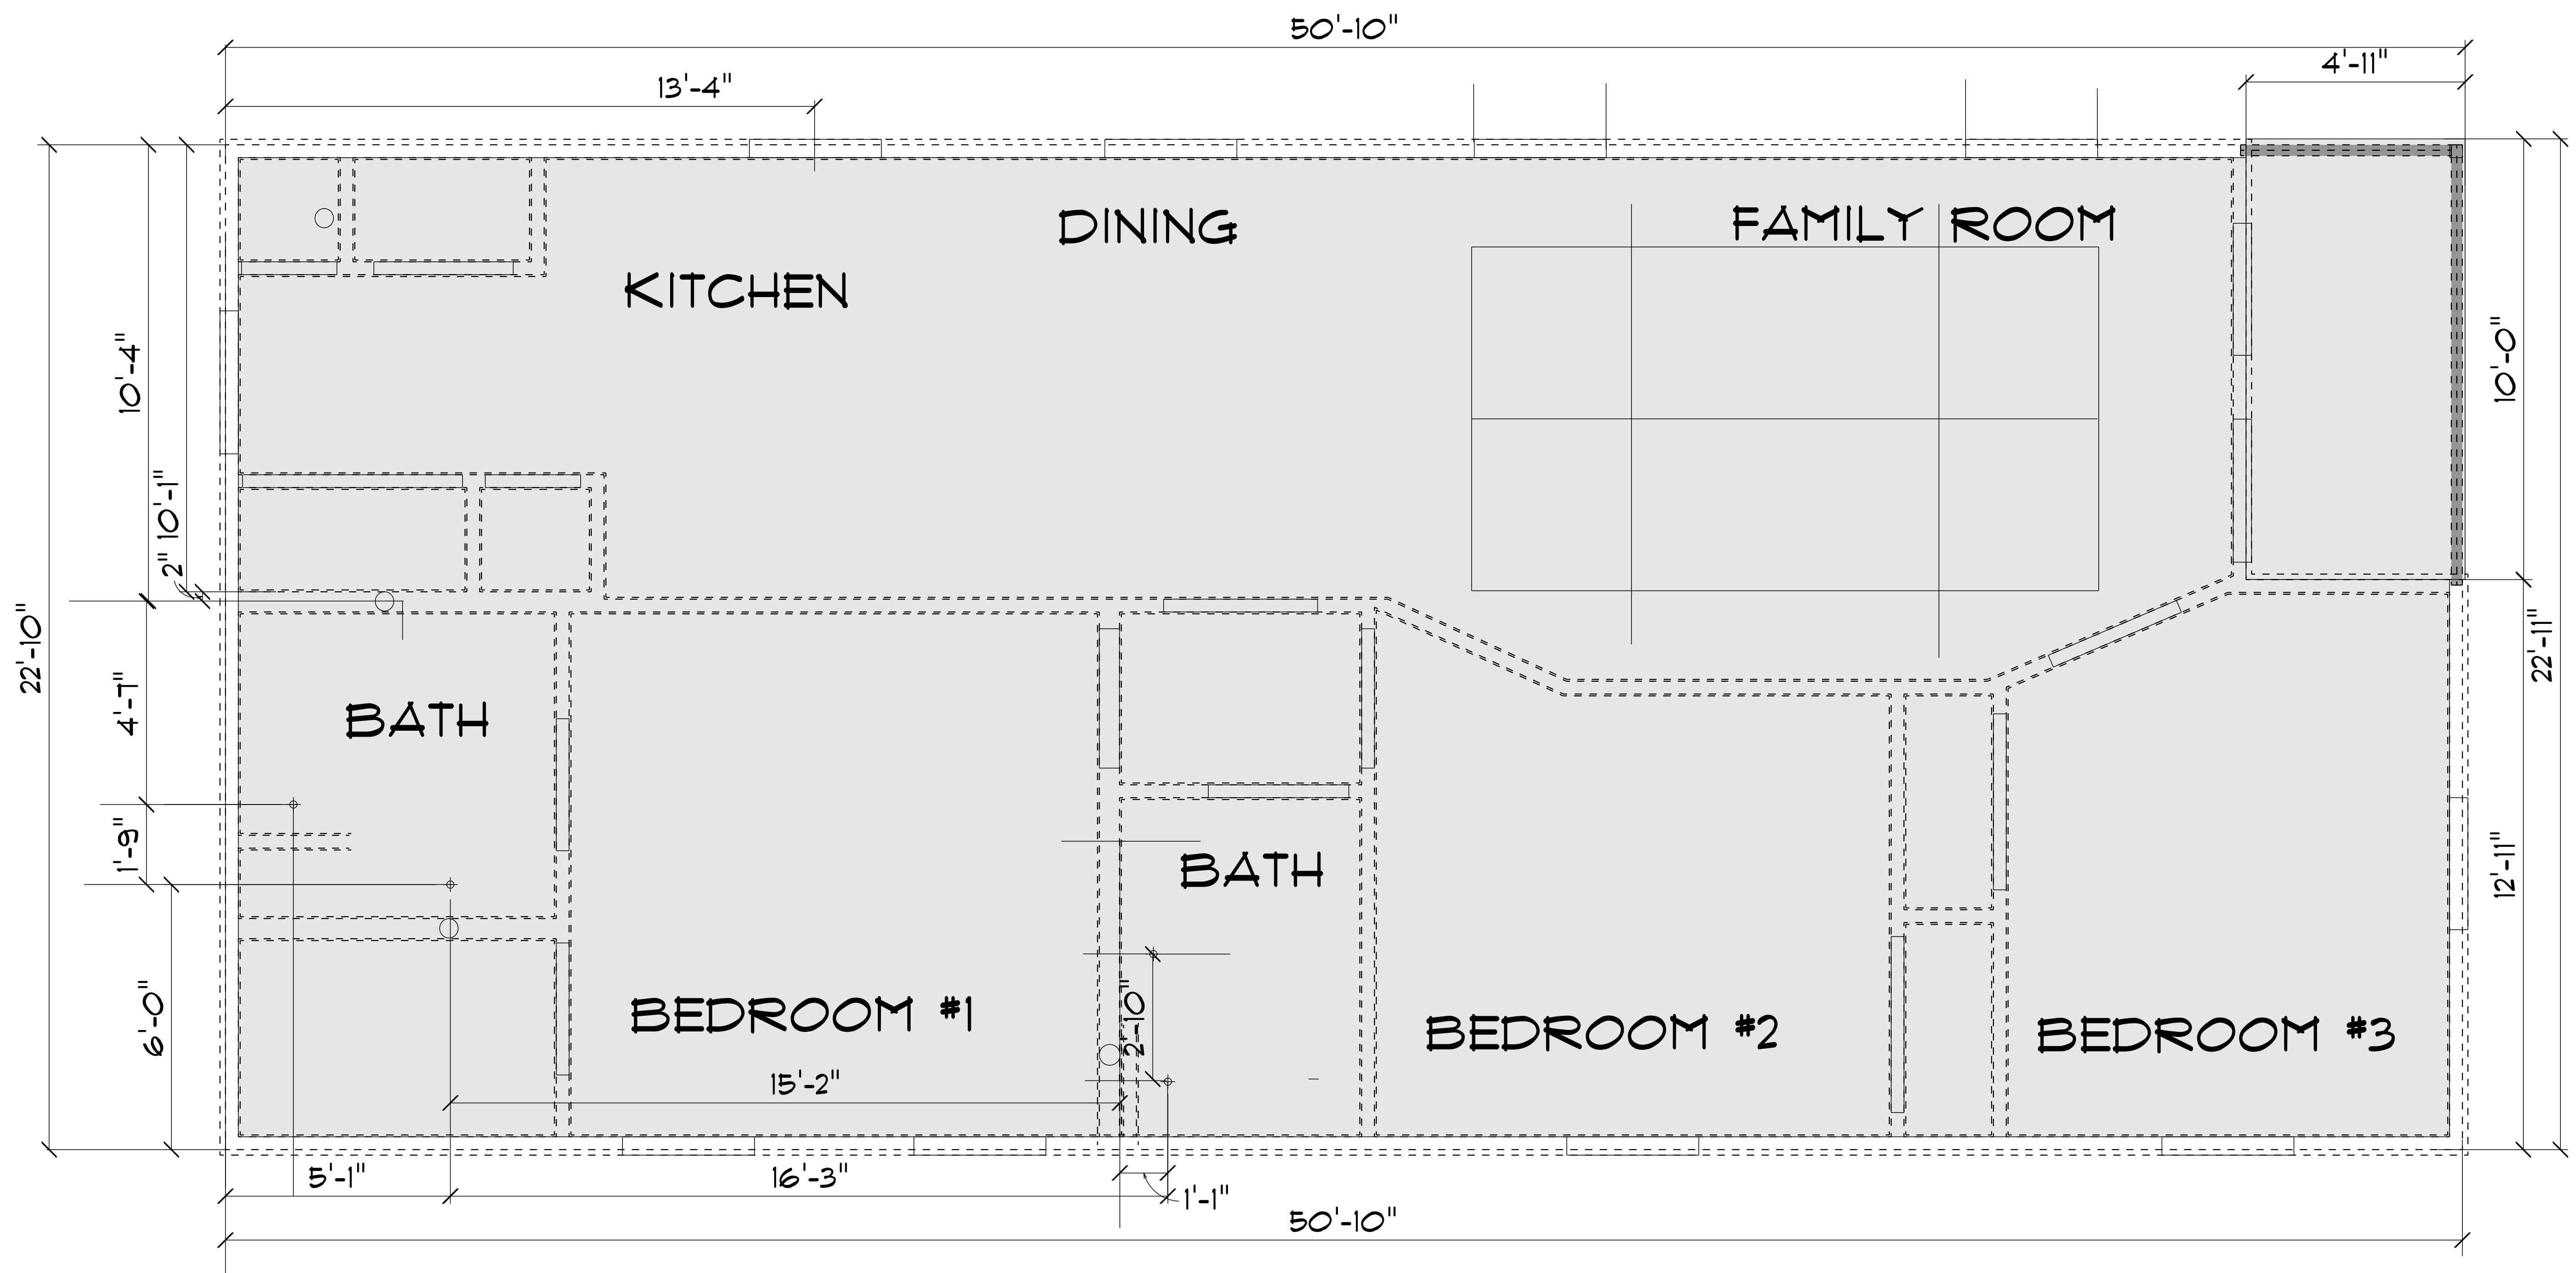


THE SHAWNEE - FLOOR SYSTEM

SCALE: 1/2" = 1'-0"

NOTE: THESE PLANS ARE NOT DETAILED DOCUMENTS THAT OUTLINE AND DELINEATE ALL ACCEPTED CONSTRUCTION PRACTICES. THE BUILDER MUST HAVE THE FIELD EXPERIENCE AND ABILITY TO SOLVE BUILDING ISSUES AND CONFLICTS. ALL SUBCONTRACTORS SHOULD BE PROFICIENT IN THEIR ABILITY TO INTERPRET PLANS, UNDERSTAND AND FOLLOW CODE REQUIREMENTS AND ACCEPTABLE CONSTRUCTION PRACTICES IN THE CONSTRUCTION PROCESS.

LCJ DESIGN LLC. IS NOT RESPONSIBLE FOR ANY CONSTRUCTION ISSUES NOT DISCUSSED PRIOR TO BEGINNING CONSTRUCTION. DISCOVERY OF ANY, ERRORS OR OMISSIONS IN THESE DOCUMENTS ARE TO BE BROUGHT TO THE IMMEDIATE ATTENTION OF LCJ DESIGN LLC. PRIOR TO ANY CONSTRUCTION WORK OR PURCHASES. ALL DIMENSIONS AND CLEARANCES TO BE VERIFIED BY OWNER/CONTRACTOR PRIOR TO BEGINNING ANY CONSTRUCTION. LCJ DESIGN LLC. IS NOT RESPONSIBLE FOR ANY CONSTRUCTION ISSUES WHICH MAY ARISE DURING OR AFTER THE CONSTRUCTION OF THIS BUILDING. THERE ARE NO GUARANTEES OR WARRANTIES SPECIFIC OR IMPLIED ASSOCIATED WITH THESE DESIGN DOCUMENTS.

<p>DESIGN, LLC. LCJ Design 5526 N Cleveland Street Dayton, Texas 77535 PHONE: 936-402-2166 FAX: 936-402-2166 MOBILE: 639-402-2166 jdbrown@lcjdesign.net</p>	<p>SECTION LETTER A PAGE NUMBERS 11</p>	<p>All Services Consulting</p> <p>PHONE: FAX: MOBILE:</p>	
		<p>DRAWN BY:</p> <p>SCALE: 1/2" = 1'-0"</p> <p>DATE: Saturday, October 8, 2011</p>	<p>PAGE:</p> <p>2/11</p> <p>Plumbing Drop</p>

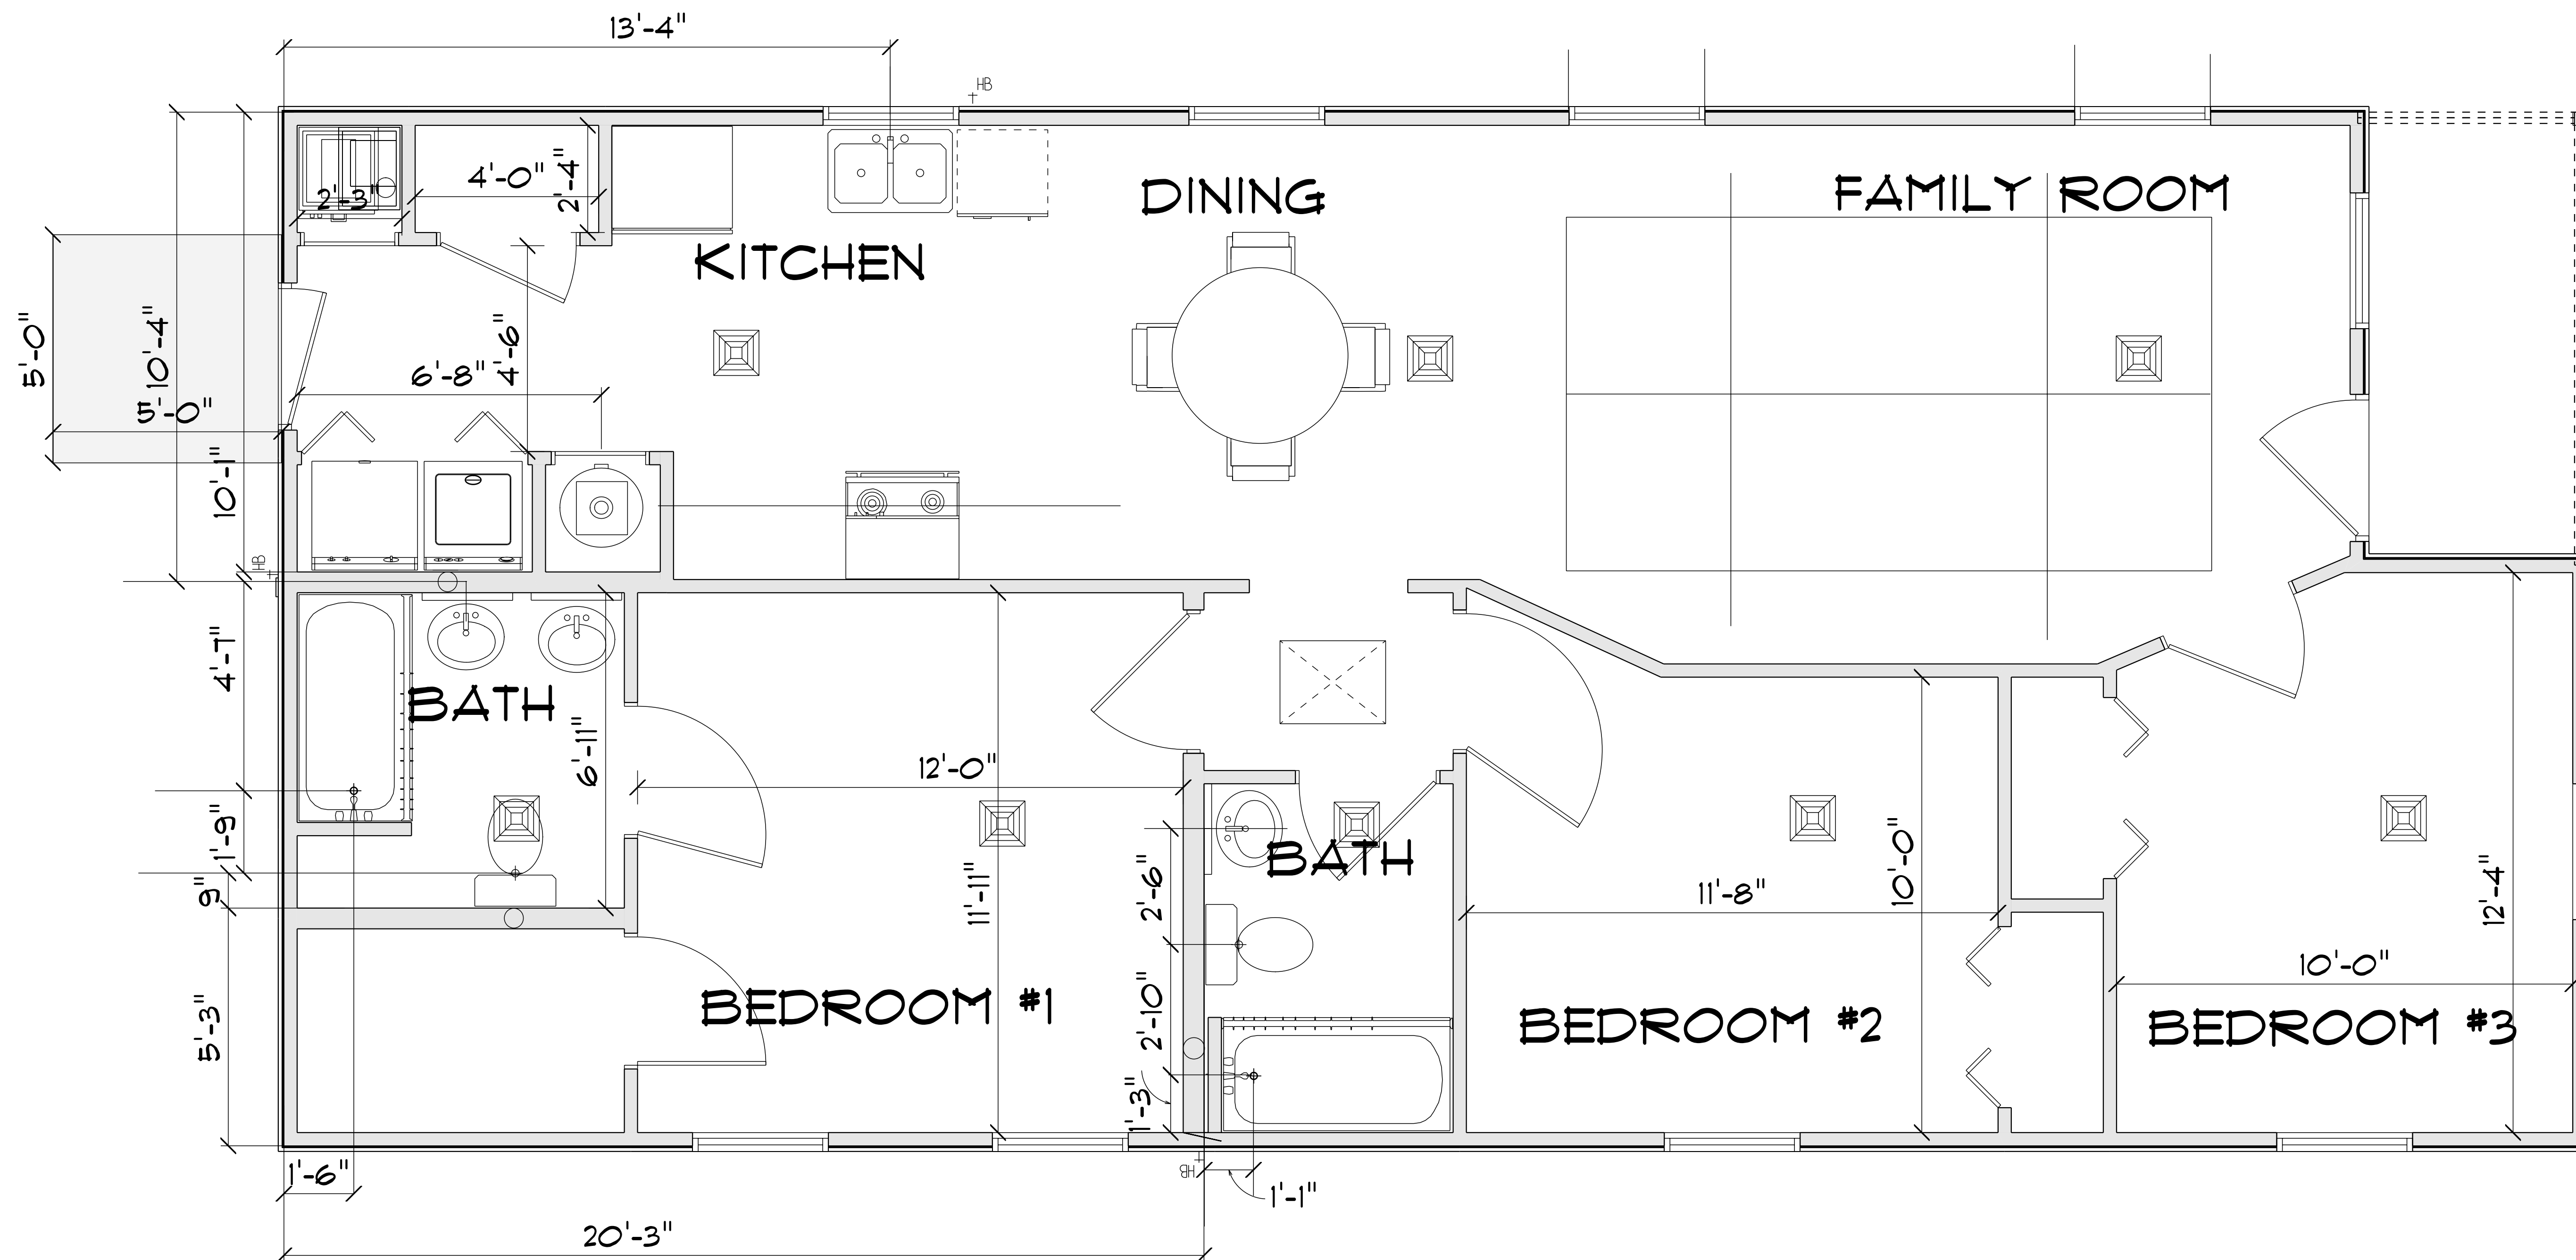


THE SHAWNEE
SCALE: 1/2" = 1'-0"

- All walls 2 x 4 except
2 x 6 Plumbing walls
- ⊗ Washer / Dryer & Master Bath Tub & Sink
 - ⊗ Master Closet & Toilet
 - ⊗ Hall Bath "Wet Wall"

NOTE: THESE PLANS ARE NOT DETAILED DOCUMENTS THAT OUTLINE AND DELINEATE ALL ACCEPTED CONSTRUCTION PRACTICES. THE BUILDER MUST HAVE THE FIELD EXPERIENCE AND ABILITY TO SOLVE BUILDING ISSUES AND CONFLICTS. ALL SUBCONTRACTORS SHOULD BE PROFICIENT IN THEIR ABILITY TO INTERPRET PLANS, UNDERSTAND AND FOLLOW CODE REQUIREMENTS AND ACCEPTABLE CONSTRUCTION PRACTICES IN THE CONSTRUCTION PROCESS.

LCJ DESIGN LLC. IS NOT RESPONSIBLE FOR ANY CONSTRUCTION ISSUES NOT DISCUSSED PRIOR TO BEGINNING CONSTRUCTION. DISCOVERY OF ANY, ERRORS OR OMISSIONS IN THESE DOCUMENTS ARE TO BE BROUGHT TO THE IMMEDIATE ATTENTION OF LCJ DESIGN LLC. PRIOR TO ANY CONSTRUCTION WORK OR PURCHASES. ALL DIMENSIONS AND CLEARANCES TO BE VERIFIED BY OWNER/CONTRACTOR PRIOR TO BEGINNING ANY CONSTRUCTION. LCJ DESIGN LLC. IS NOT RESPONSIBLE FOR ANY CONSTRUCTION ISSUES WHICH MAY ARISE DURING OR AFTER THE CONSTRUCTION OF THIS BUILDING. THERE ARE NO GUARANTEES OR WARRANTIES SPECIFIC OR IMPLIED ASSOCIATED WITH THESE DESIGN DOCUMENTS.

<p>DESIGN, LLC. LCJ Design 5526 N Cleveland Street Dayton, Texas 77535</p>	<p>PHONE: 936-402-2166 FAX: 936-402-2166 MOBILE: 639-402-2166 jdbrown@lcjdesign.net</p>	<p>SECTION LETTER A PAGE NUMBERS 11</p>	<p>All Services Consulting</p>	
			<p>PHONE: FAX: MOBILE:</p>	<p>DRAWN BY: SCALE: 1/2" = 1'-0" DATE: Saturday, October 9, 2021</p>

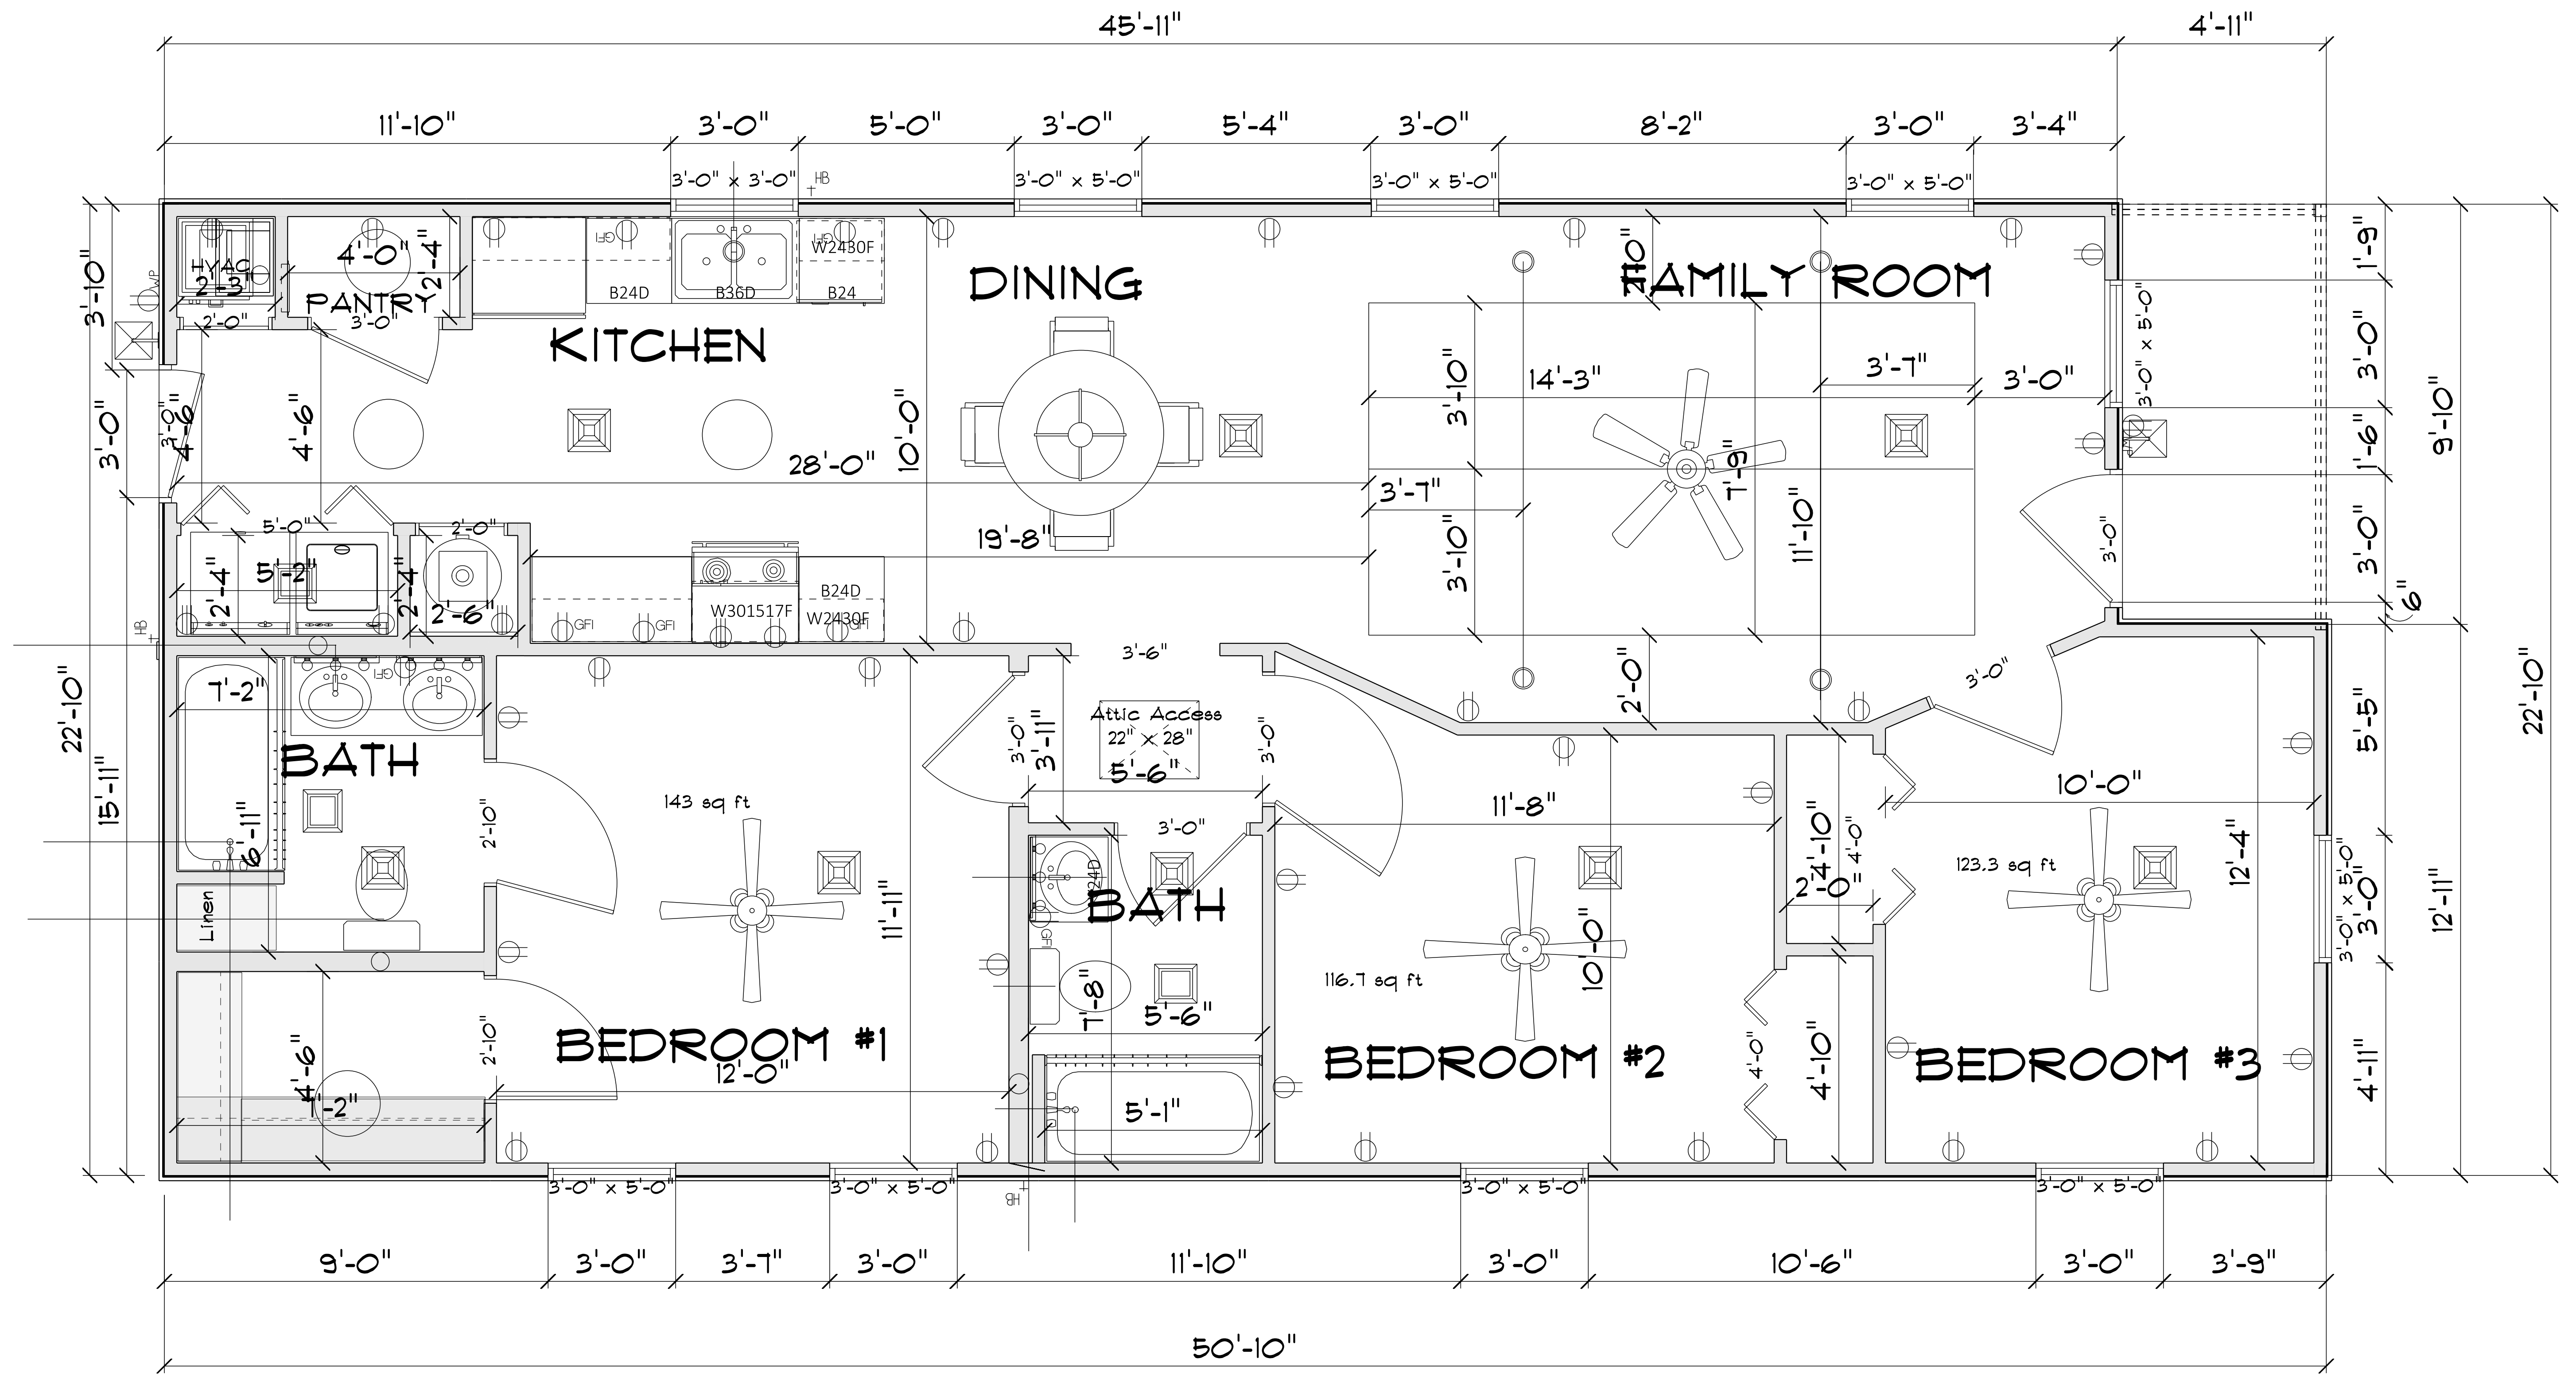


Living 1130 Sq. Ft.
Porch 50 Sq. Ft.

THE SHAWNEE
SCALE: 1/2" = 1'-0"

NOTE: THESE PLANS ARE NOT DETAILED DOCUMENTS THAT OUTLINE AND DELINEATE ALL ACCEPTED CONSTRUCTION PRACTICES. THE BUILDER MUST HAVE THE FIELD EXPERIENCE AND ABILITY TO SOLVE BUILDING ISSUES AND CONFLICTS. ALL SUBCONTRACTORS SHOULD BE PROFICIENT IN THEIR ABILITY TO INTERPRET PLANS, UNDERSTAND AND FOLLOW CODE REQUIREMENTS AND ACCEPTABLE CONSTRUCTION PRACTICES IN THE CONSTRUCTION PROCESS.

LCJ DESIGN LLC. IS NOT RESPONSIBLE FOR ANY CONSTRUCTION ISSUES NOT DISCUSSED PRIOR TO BEGINNING CONSTRUCTION. DISCOVERY OF ANY, ERRORS OR OMISSIONS IN THESE DOCUMENTS ARE TO BE BROUGHT TO THE IMMEDIATE ATTENTION OF LCJ DESIGN LLC. PRIOR TO ANY CONSTRUCTION WORK OR PURCHASES. ALL DIMENSIONS AND CLEARANCES TO BE VERIFIED BY OWNER/CONTRACTOR PRIOR TO BEGINNING ANY CONSTRUCTION. LCJ DESIGN LLC. IS NOT RESPONSIBLE FOR ANY CONSTRUCTION ISSUES WHICH MAY ARISE DURING OR AFTER THE CONSTRUCTION OF THIS BUILDING. THERE ARE NO GUARANTEES OR WARRANTIES SPECIFIC OR IMPLIED ASSOCIATED WITH THESE DESIGN DOCUMENTS.

DESIGN, LLC.
LCJ Design
5526 N Cleveland Street
Dayton, Texas 77535
PHONE: 936-402-2166
FAX: 639-402-2166
MOBILE: 639-402-2166
jdbrown@lcjdesign.net

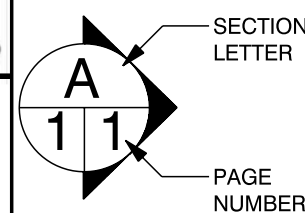


All Services Consulting

PHONE:
FAX:
MOBILE:

DRAWN BY:
SCALE: 1/2" = 1'-0"
DATE: Saturday, October 9, 2021

PAGE:
4/11
Floor Plan

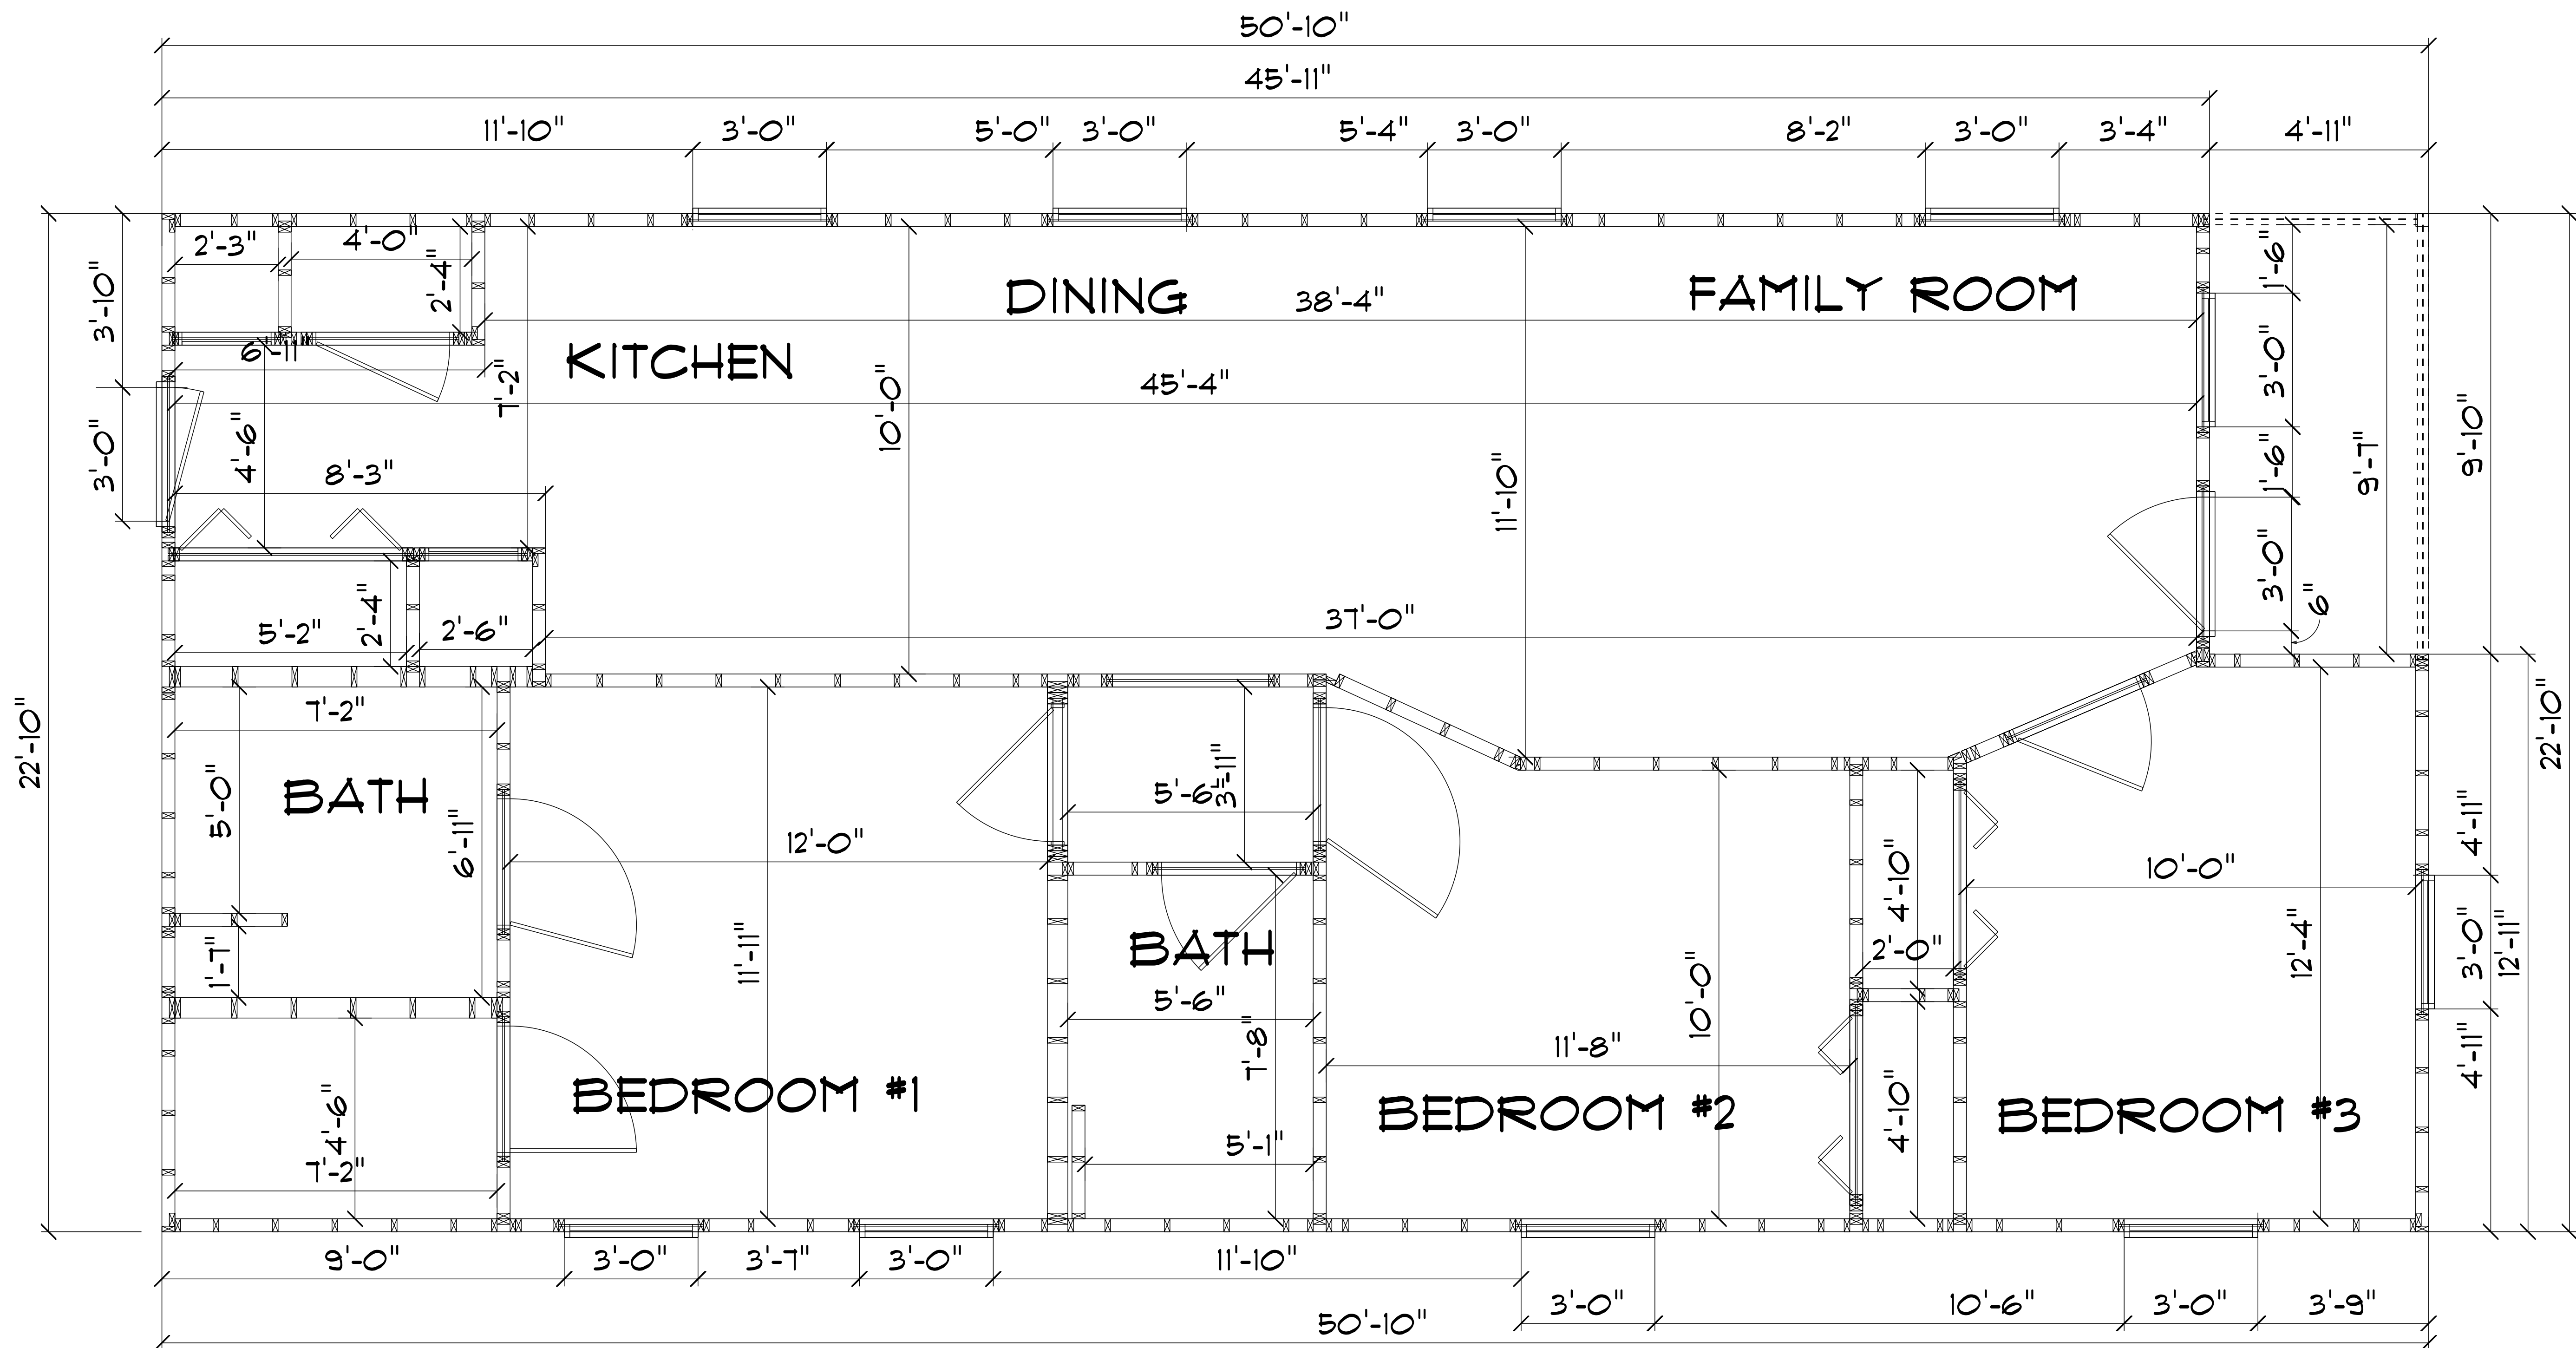

THE SHAWNEE - FRAMING

SCALE: 1/2" = 1'-0"

NOTE: THESE PLANS ARE NOT DETAILED DOCUMENTS THAT OUTLINE AND DELINEATE ALL ACCEPTED CONSTRUCTION PRACTICES. THE BUILDER MUST HAVE THE FIELD EXPERIENCE AND ABILITY TO SOLVE BUILDING ISSUES AND CONFLICTS. ALL SUBCONTRACTORS SHOULD BE PROFICIENT IN THEIR ABILITY TO INTERPRET PLANS, UNDERSTAND AND FOLLOW CODE REQUIREMENTS AND ACCEPTABLE CONSTRUCTION PRACTICES IN THE CONSTRUCTION PROCESS.

LCJ DESIGN LLC. IS NOT RESPONSIBLE FOR ANY CONSTRUCTION ISSUES NOT DISCUSSED PRIOR TO BEGINNING CONSTRUCTION. DISCOVERY OF ANY, ERRORS OR OMISSIONS IN THESE DOCUMENTS ARE TO BE BROUGHT TO THE IMMEDIATE ATTENTION OF LCJ DESIGN LLC. PRIOR TO ANY CONSTRUCTION WORK OR PURCHASES. ALL DIMENSIONS AND CLEARANCES TO BE VERIFIED BY OWNER/CONTRACTOR PRIOR TO BEGINNING CONSTRUCTION. LCJ DESIGN LLC. IS NOT RESPONSIBLE FOR ANY CONSTRUCTION ISSUES WHICH MAY ARISE DURING OR AFTER THE CONSTRUCTION OF THIS BUILDING. THERE ARE NO GUARANTEES OR WARRANTIES SPECIFIC OR IMPLIED ASSOCIATED WITH THESE DESIGN DOCUMENTS.

CABINET SCHEDULE

NAME	WIDTH	DEPTH	HEIGHT	COUNT
B21D	21.000"	24.000"	34.500"	1
B24	24.000"	24.000"	34.500"	1
B24D	24.000"	24.000"	34.500"	3
B36D	36.000"	24.000"	34.500"	1
V24D	24.000"	22.000"	30.500"	1
V54D	54.000"	22.000"	30.500"	1
W2130F	21.000"	12.000"	30.000"	1
W2430F	23.841"	12.000"	30.000"	1
W2430F	24.000"	12.000"	30.000"	3
W301817F	30.000"	17.000"	18.000"	1
W3220F	32.000"	12.000"	20.000"	1


DOOR SCHEDULE

PRODUCT CODE	SIZE	HINGE	COUNT
36X80 COLONIAL A 1	3'-0"	L	1
36X80 COUNTRY A 1-MODIFIED	3'-0"	L	1
48X80 BIFOLD COLONIAL 2	4'-0"	LR	2
60X80 BIFOLD COLONIAL 2	5'-0"	LR	1
24X80 COLONIAL B 1	2'-0"	L	1
24X80 COLONIAL B 1	2'-0"	R	1
36X80 COLONIAL A 1	3'-0"	R	1
36X80 COLONIAL B 1-MODIFIED	3'-0"	R	1
36X80 COLONIAL B 1	3'-0"	L	4

WINDOW SCHEDULE


PRODUCT CODE	SIZE	COUNT
36X36 SINGLE HUNG 1	3'-0" x 3'-0"	1
36X60 SINGLE HUNG 1	3'-0" x 5'-0"	9

DESIGN, LLC.
 LCJ Design
 5526 N Cleveland Street
 Dayton, Texas 77535
 PHONE: 936-402-2166
 FAX: 936-402-2166
 MOBILE: 639-402-2166
 jdbrown@lcjdesign.net

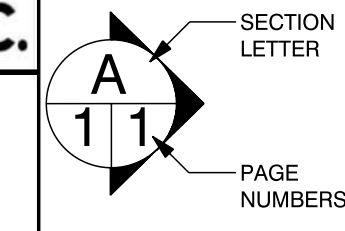

All Services Consulting
 PHONE: _____
 FAX: _____
 MOBILE: _____
 DRAWN BY: _____
 SCALE: 1/2" = 1'-0"
 DATE: Saturday, October 9, 2021
 PAGE: 5/11
 Framing Details

12" Step Up Trey Ceiling
Joist @ 16" O. C.

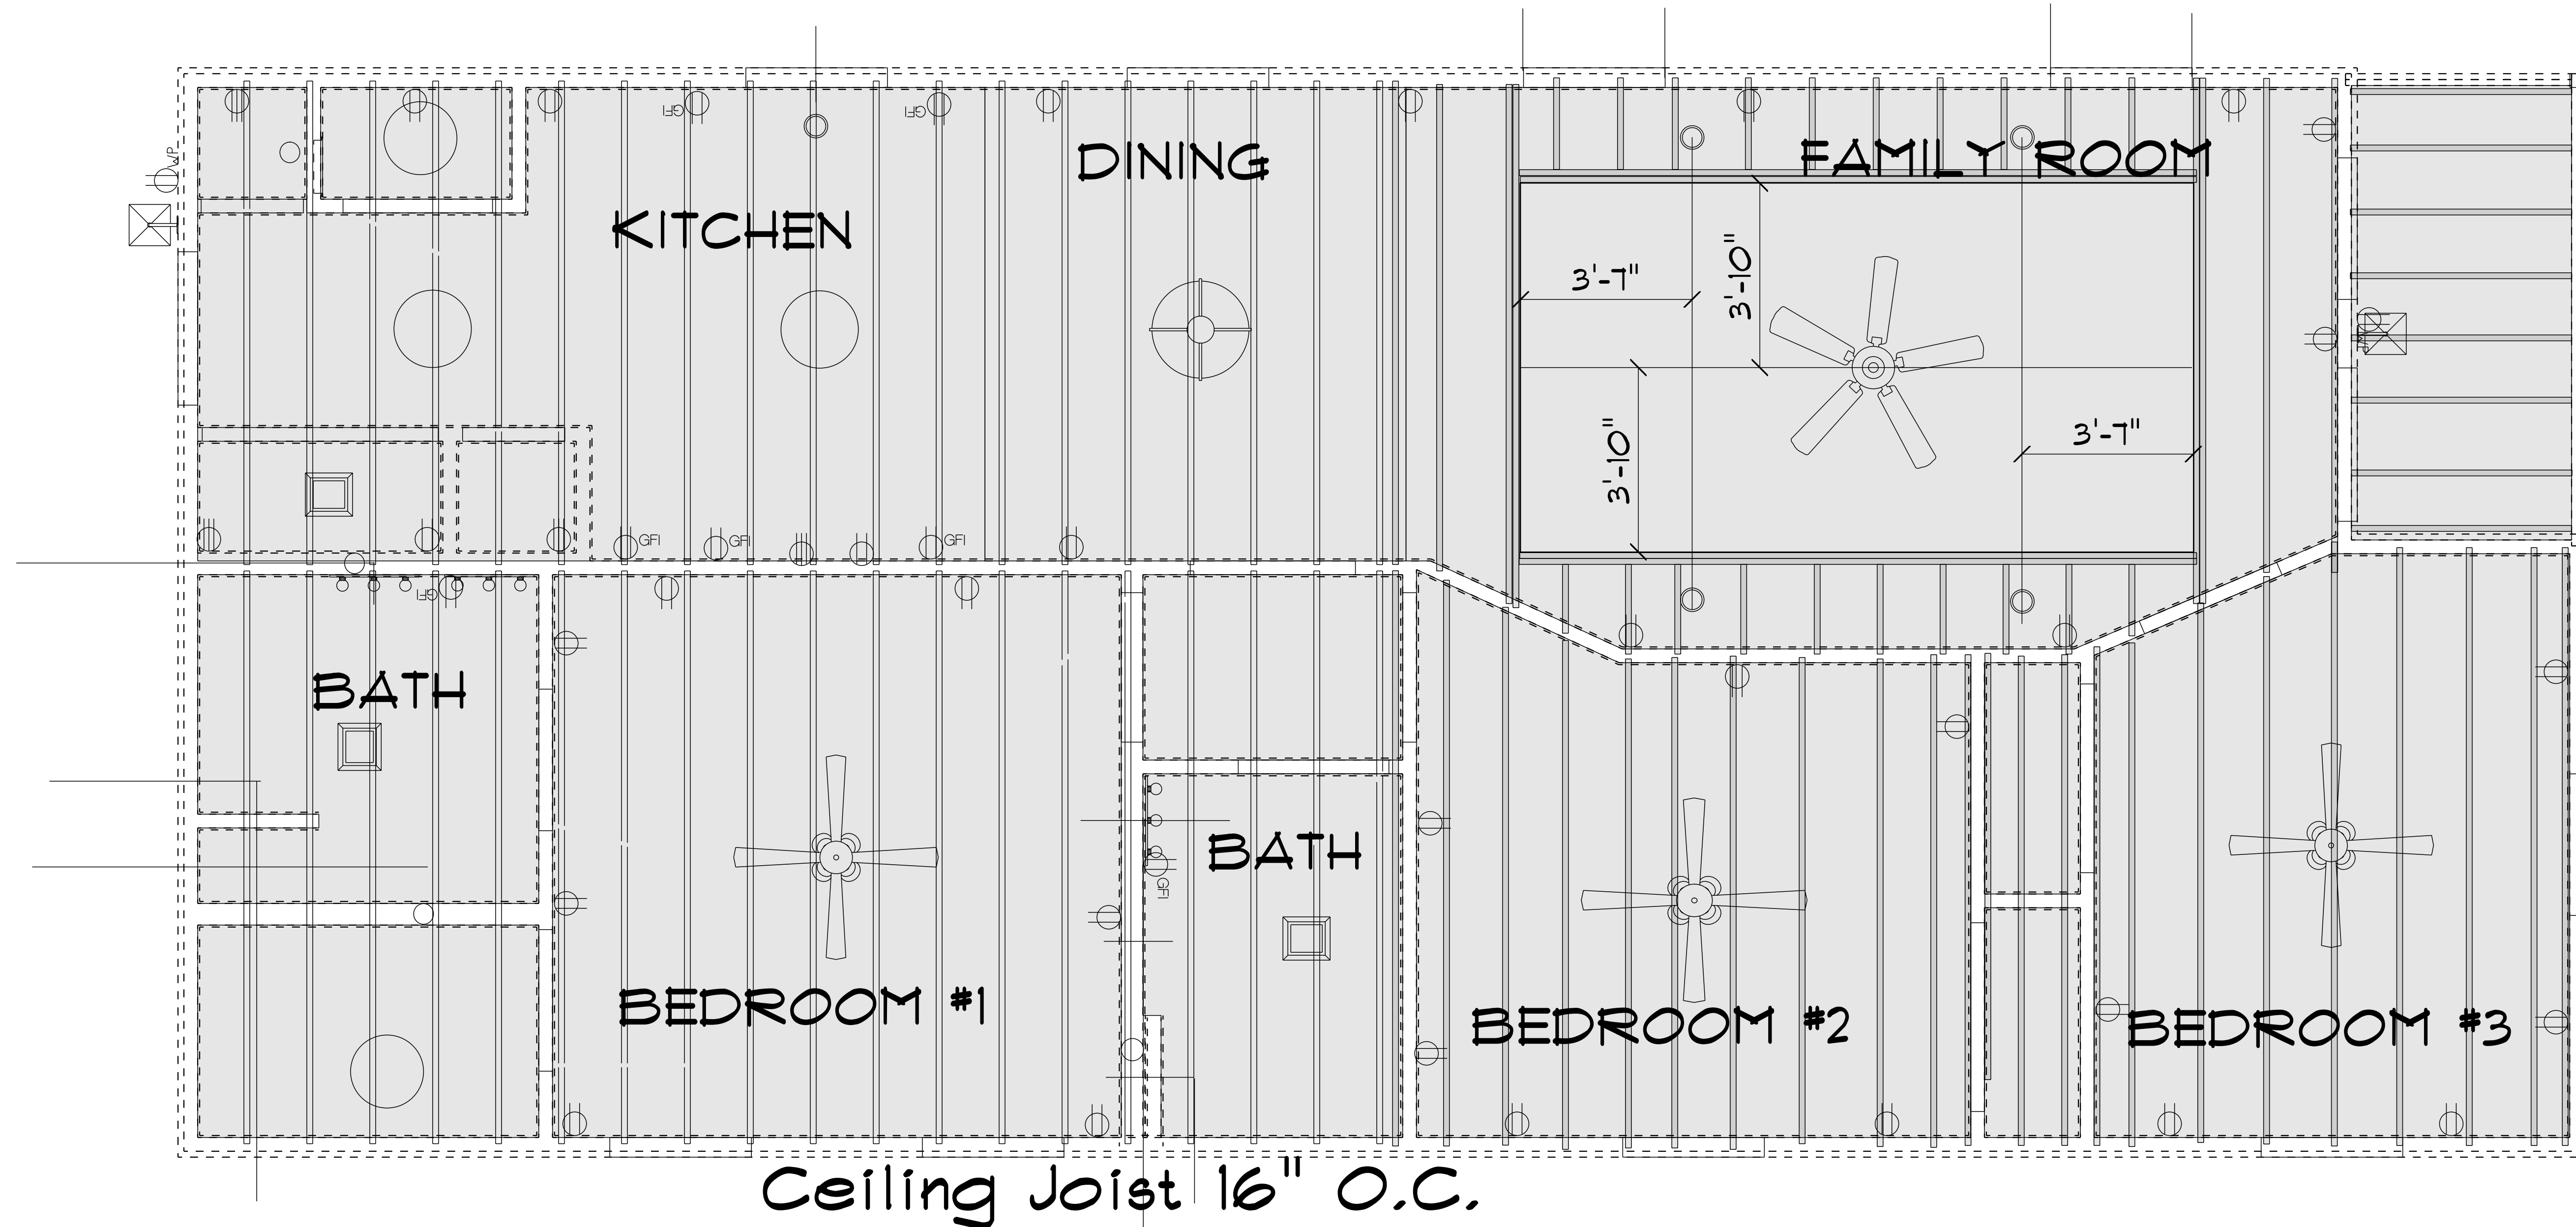


Ceiling Joist 16" O.C.

NOTE: THESE PLANS ARE NOT DETAILED DOCUMENTS THAT OUTLINE AND DELINEATE ALL ACCEPTED CONSTRUCTION PRACTICES. THE BUILDER MUST HAVE THE FIELD EXPERIENCE AND ABILITY TO SOLVE BUILDING ISSUES AND CONFLICTS. ALL SUBCONTRACTORS SHOULD BE PROFICIENT IN THEIR ABILITY TO INTERPRET PLANS, UNDERSTAND AND FOLLOW CODE REQUIREMENTS AND ACCEPTABLE CONSTRUCTION PRACTICES IN THE CONSTRUCTION PROCESS.

LCJ DESIGN LLC. IS NOT RESPONSIBLE FOR ANY CONSTRUCTION ISSUES NOT DISCUSSED PRIOR TO BEGINNING CONSTRUCTION. DISCOVERY OF ANY, ERRORS OR OMISSIONS IN THESE DOCUMENTS ARE TO BE BROUGHT TO THE IMMEDIATE ATTENTION OF LCJ DESIGN LLC. PRIOR TO ANY CONSTRUCTION WORK OR PURCHASES. ALL DIMENSIONS AND CLEARANCES TO BE VERIFIED BY OWNER/CONTRACTOR PRIOR TO BEGINNING ANY CONSTRUCTION. LCJ DESIGN LLC. IS NOT RESPONSIBLE FOR ANY CONSTRUCTION ISSUES WHICH MAY ARISE DURING OR AFTER THE CONSTRUCTION OF THIS BUILDING. THERE ARE NO GUARANTEES OR WARRANTIES SPECIFIC OR IMPLIED ASSOCIATED WITH THESE DESIGN DOCUMENTS.

THE SHAWNEE - CEILING
SCALE: 1/2" = 1'-0"

<p>DESIGN, LLC. LCJ Design 5526 N Cleveland Street Dayton, Texas 77535 PHONE: 936-402-2166 FAX: 936-402-2166 MOBILE: 639-402-2166 jdbrown@lcjdesign.net</p>	<p>SECTION LETTER A PAGE NUMBERS 11</p>	<p>All Services Consulting</p> <p>PHONE: FAX: MOBILE:</p>	
		<p>DRAWN BY:</p> <p>SCALE: 1/2" = 1'-0"</p> <p>DATE: Saturday, October 9, 2021</p>	<p>PAGE: 6/11 Ceiling</p>

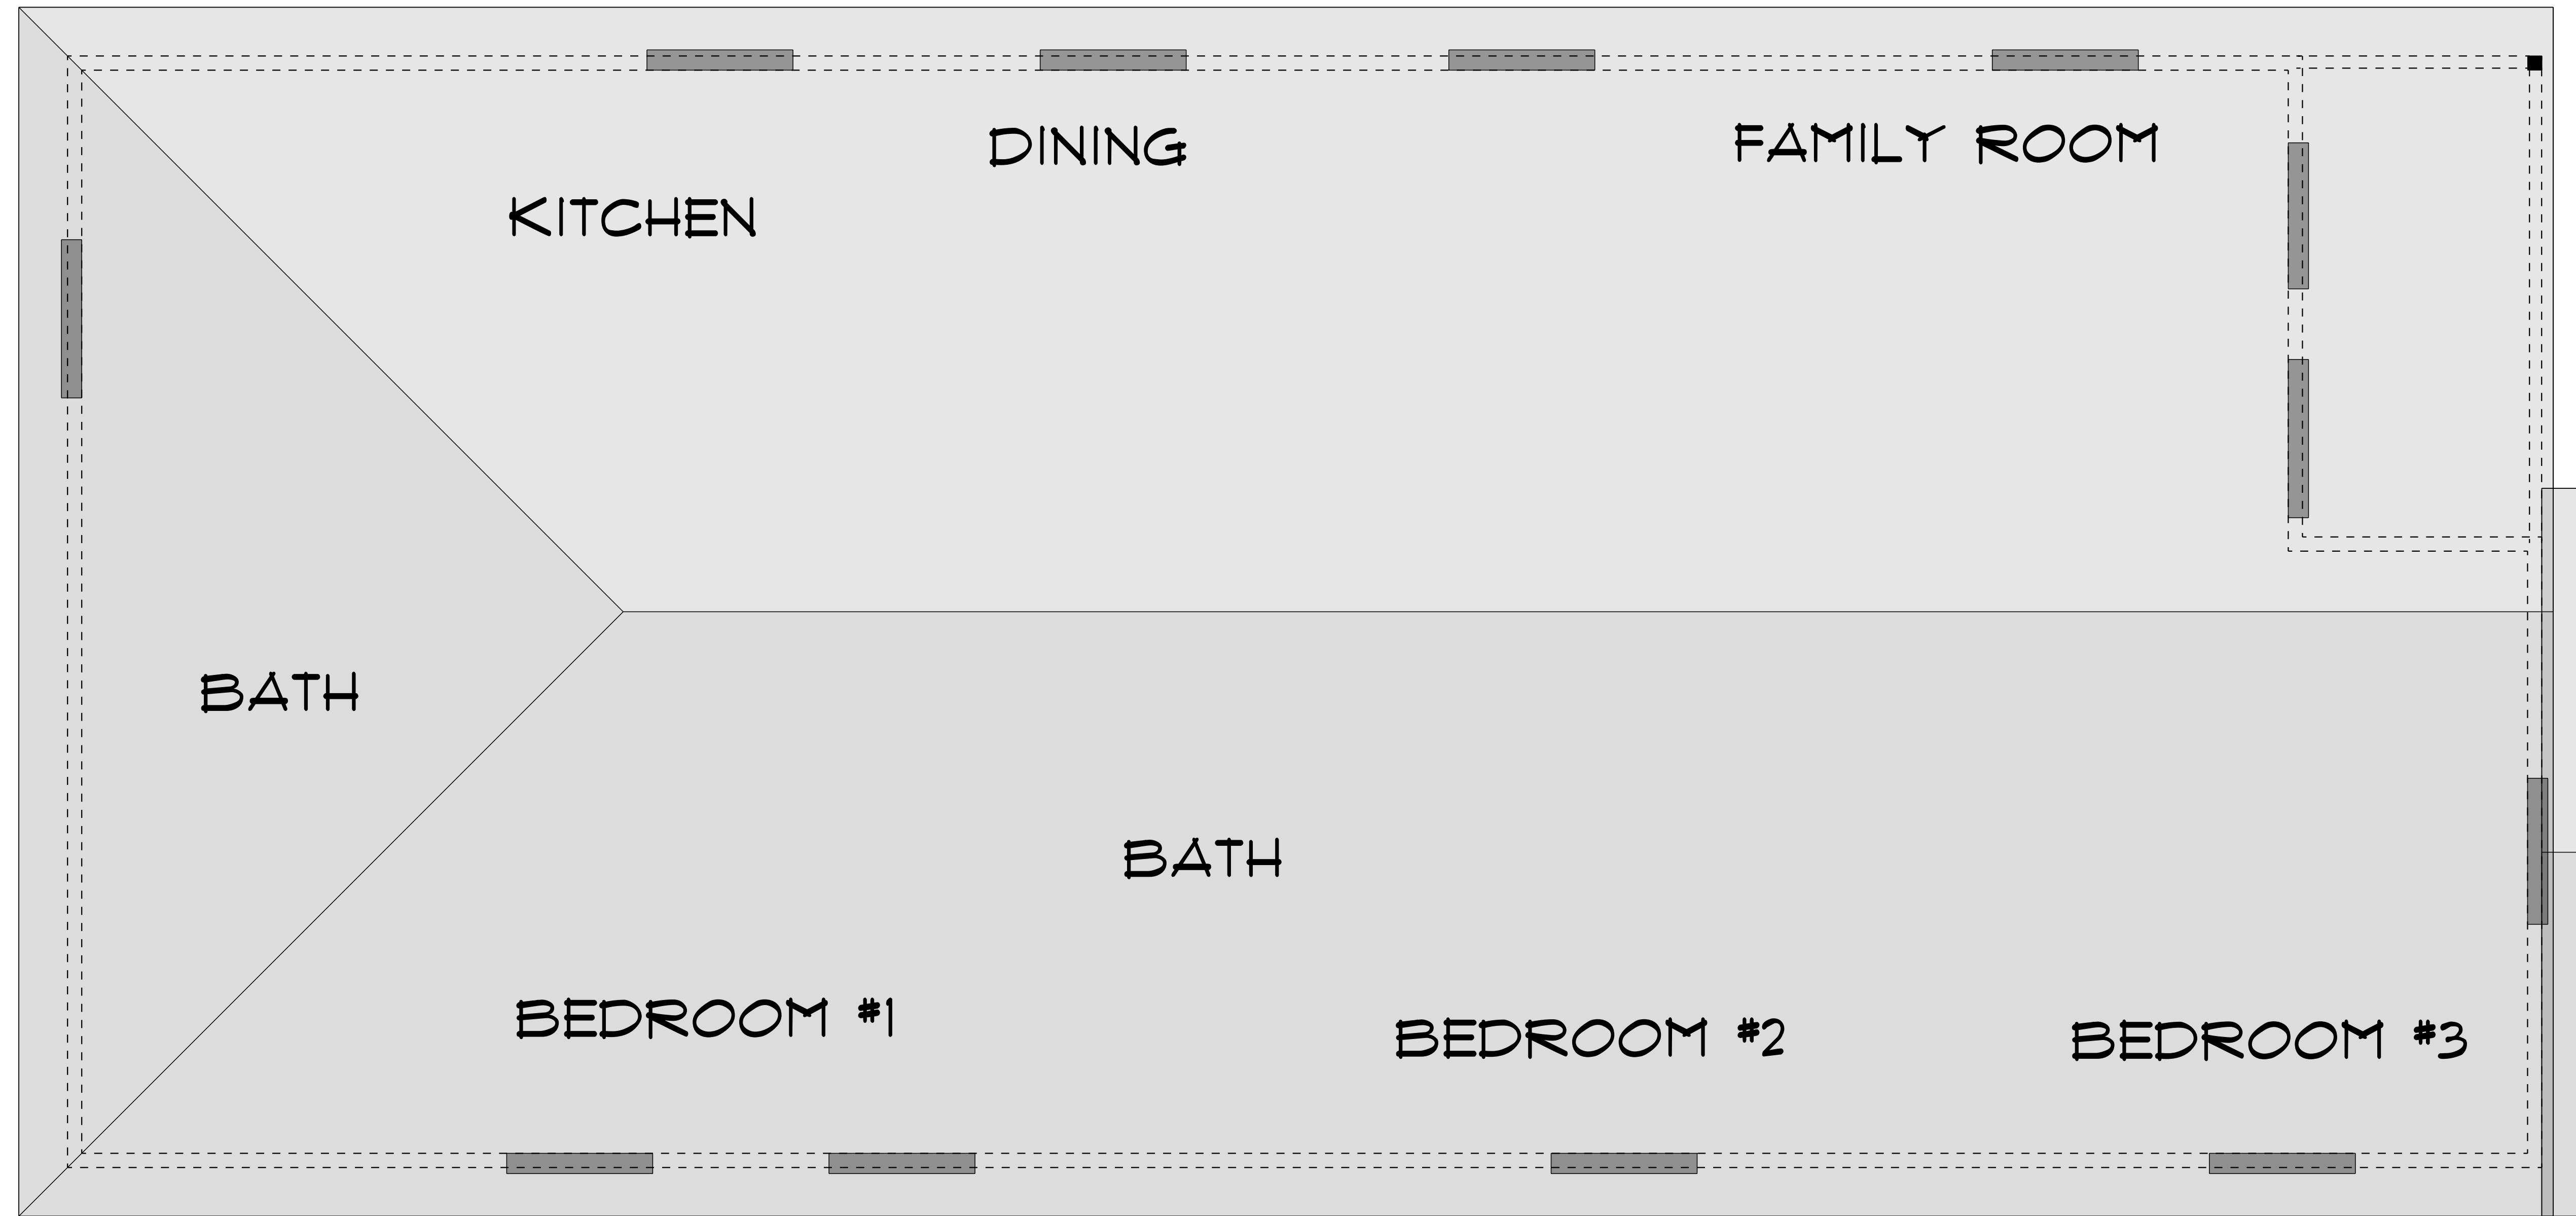
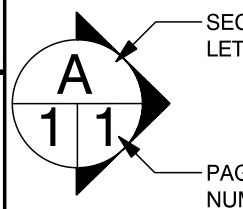



THE SHAWNEE - ROOF
 SCALE: 1/2" = 1'-0"

6" Pitch
 Rafters 24" O. C.

NOTE: THESE PLANS ARE NOT DETAILED DOCUMENTS THAT OUTLINE AND DELINEATE ALL ACCEPTED CONSTRUCTION PRACTICES. THE BUILDER MUST HAVE THE FIELD EXPERIENCE AND ABILITY TO SOLVE BUILDING ISSUES AND CONFLICTS. ALL SUBCONTRACTORS SHOULD BE PROFICIENT IN THEIR ABILITY TO INTERPRET PLANS, UNDERSTAND AND FOLLOW CODE REQUIREMENTS AND ACCEPTABLE CONSTRUCTION PRACTICES IN THE CONSTRUCTION PROCESS.

LCJ DESIGN LLC. IS NOT RESPONSIBLE FOR ANY CONSTRUCTION ISSUES NOT DISCUSSED PRIOR TO BEGINNING CONSTRUCTION. DISCOVERY OF ANY, ERRORS OR OMISSIONS IN THESE DOCUMENTS ARE TO BE BROUGHT TO THE IMMEDIATE ATTENTION OF LCJ DESIGN LLC. PRIOR TO ANY CONSTRUCTION WORK OR PURCHASES. ALL DIMENSIONS AND CLEARANCES TO BE VERIFIED BY OWNER/CONTRACTOR PRIOR TO BEGINNING ANY CONSTRUCTION. LCJ DESIGN LLC. IS NOT RESPONSIBLE FOR ANY CONSTRUCTION ISSUES WHICH MAY ARISE DURING OR AFTER THE CONSTRUCTION OF THIS BUILDING. THERE ARE NO GUARANTEES OR WARRANTIES SPECIFIC OR IMPLIED ASSOCIATED WITH THESE DESIGN DOCUMENTS.

 DESIGN, LLC. LCJ Design 5526 N Cleveland Street Dayton, Texas 77535 PHONE: 936-402-2166 FAX: 936-402-2166 MOBILE: 639-402-2166 jdbrown@lcjdesign.net	 SECTION LETTER PAGE NUMBERS	All Services Consulting PHONE: FAX: MOBILE:	
		DRAWN BY: SCALE: 1/2" = 1'-0" DATE: Saturday, October 9, 2021	PAGE: 7/11 Roof

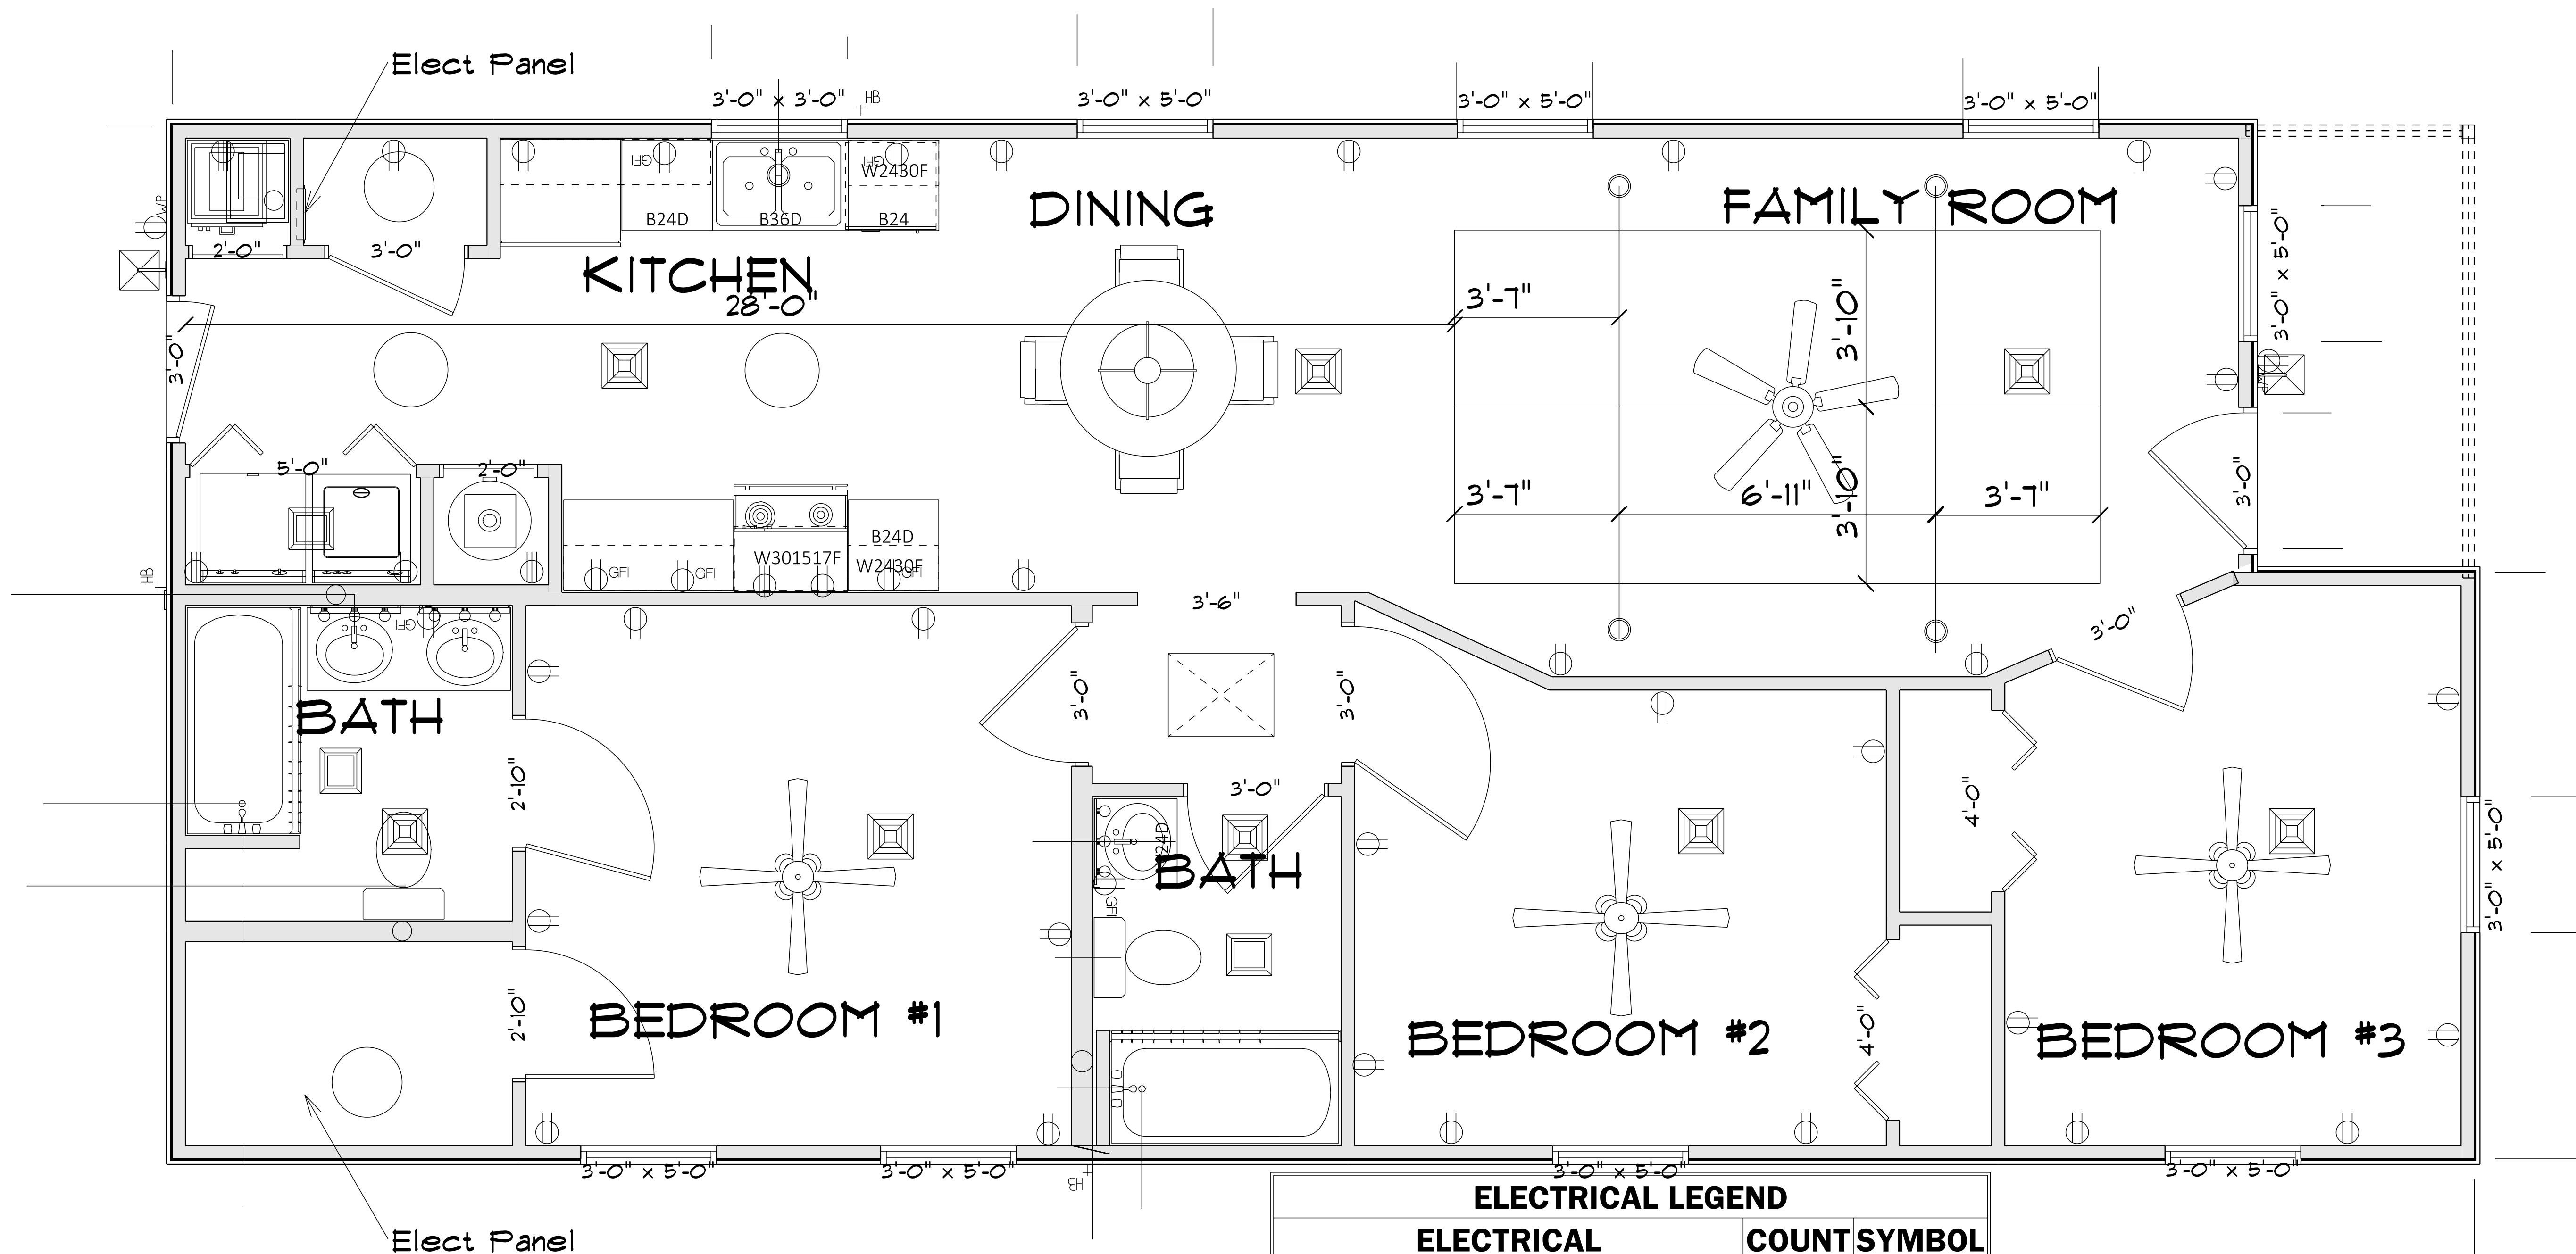


THE SHAWNEE - ELECTRICAL
SCALE: 1/2" = 1'-0"

ELECTRICAL LEGEND		
ELECTRICAL	COUNT	SYMBOL
ceiling fan 5 bladed 02	1	
ceiling fan spotlights 01	3	
can light 6inch	1	
ceiling light 03	2	
ceiling light 04	2	
ceiling light 27	1	
combination fan and light-square	3	
pot light	4	
exterior craftsman light fixture	2	
electrical panel	1	
outlet	36	
outlet 220v	4	
outlet gfi	7	
outlet wp	2	
vanity bar light 02	2	

NOTE: THESE PLANS ARE NOT DETAILED DOCUMENTS THAT OUTLINE AND DELINEATE ALL ACCEPTED CONSTRUCTION PRACTICES. THE BUILDER MUST HAVE THE FIELD EXPERIENCE AND ABILITY TO SOLVE BUILDING ISSUES AND CONFLICTS. ALL SUBCONTRACTORS SHOULD BE PROFICIENT IN THEIR ABILITY TO INTERPRET PLANS, UNDERSTAND AND FOLLOW CODE REQUIREMENTS AND ACCEPTABLE CONSTRUCTION PRACTICES IN THE CONSTRUCTION PROCESS.

LCJ DESIGN LLC. IS NOT RESPONSIBLE FOR ANY CONSTRUCTION ISSUES NOT DISCUSSED PRIOR TO BEGINNING CONSTRUCTION. DISCOVERY OF ANY, ERRORS OR OMISSIONS IN THESE DOCUMENTS ARE TO BE BROUGHT TO THE IMMEDIATE ATTENTION OF LCJ DESIGN LLC. PRIOR TO ANY CONSTRUCTION WORK OR PURCHASES. ALL DIMENSIONS AND CLEARANCES TO BE VERIFIED BY OWNER/CONTRACTOR PRIOR TO BEGINNING ANY CONSTRUCTION. LCJ DESIGN LLC. IS NOT RESPONSIBLE FOR ANY CONSTRUCTION ISSUES WHICH MAY ARISE DURING OR AFTER THE CONSTRUCTION OF THIS BUILDING. THERE ARE NO GUARANTEES OR WARRANTIES SPECIFIC OR IMPLIED ASSOCIATED WITH THESE DESIGN DOCUMENTS.

DESIGN, LLC. LCJ Design 5526 N Cleveland Street Dayton, Texas 77535 PHONE: 936-402-2166 FAX: 639-402-2166 MOBILE: 639-402-2166 jdbrown@lcjdesign.net	SECTION LETTER PAGE NUMBERS	All Services Consulting PHONE: FAX: MOBILE:	
		DRAWN BY: SCALE: 1/2" = 1'-0" DATE: Saturday, October 9, 2021	PAGE: 8/11 Electrical

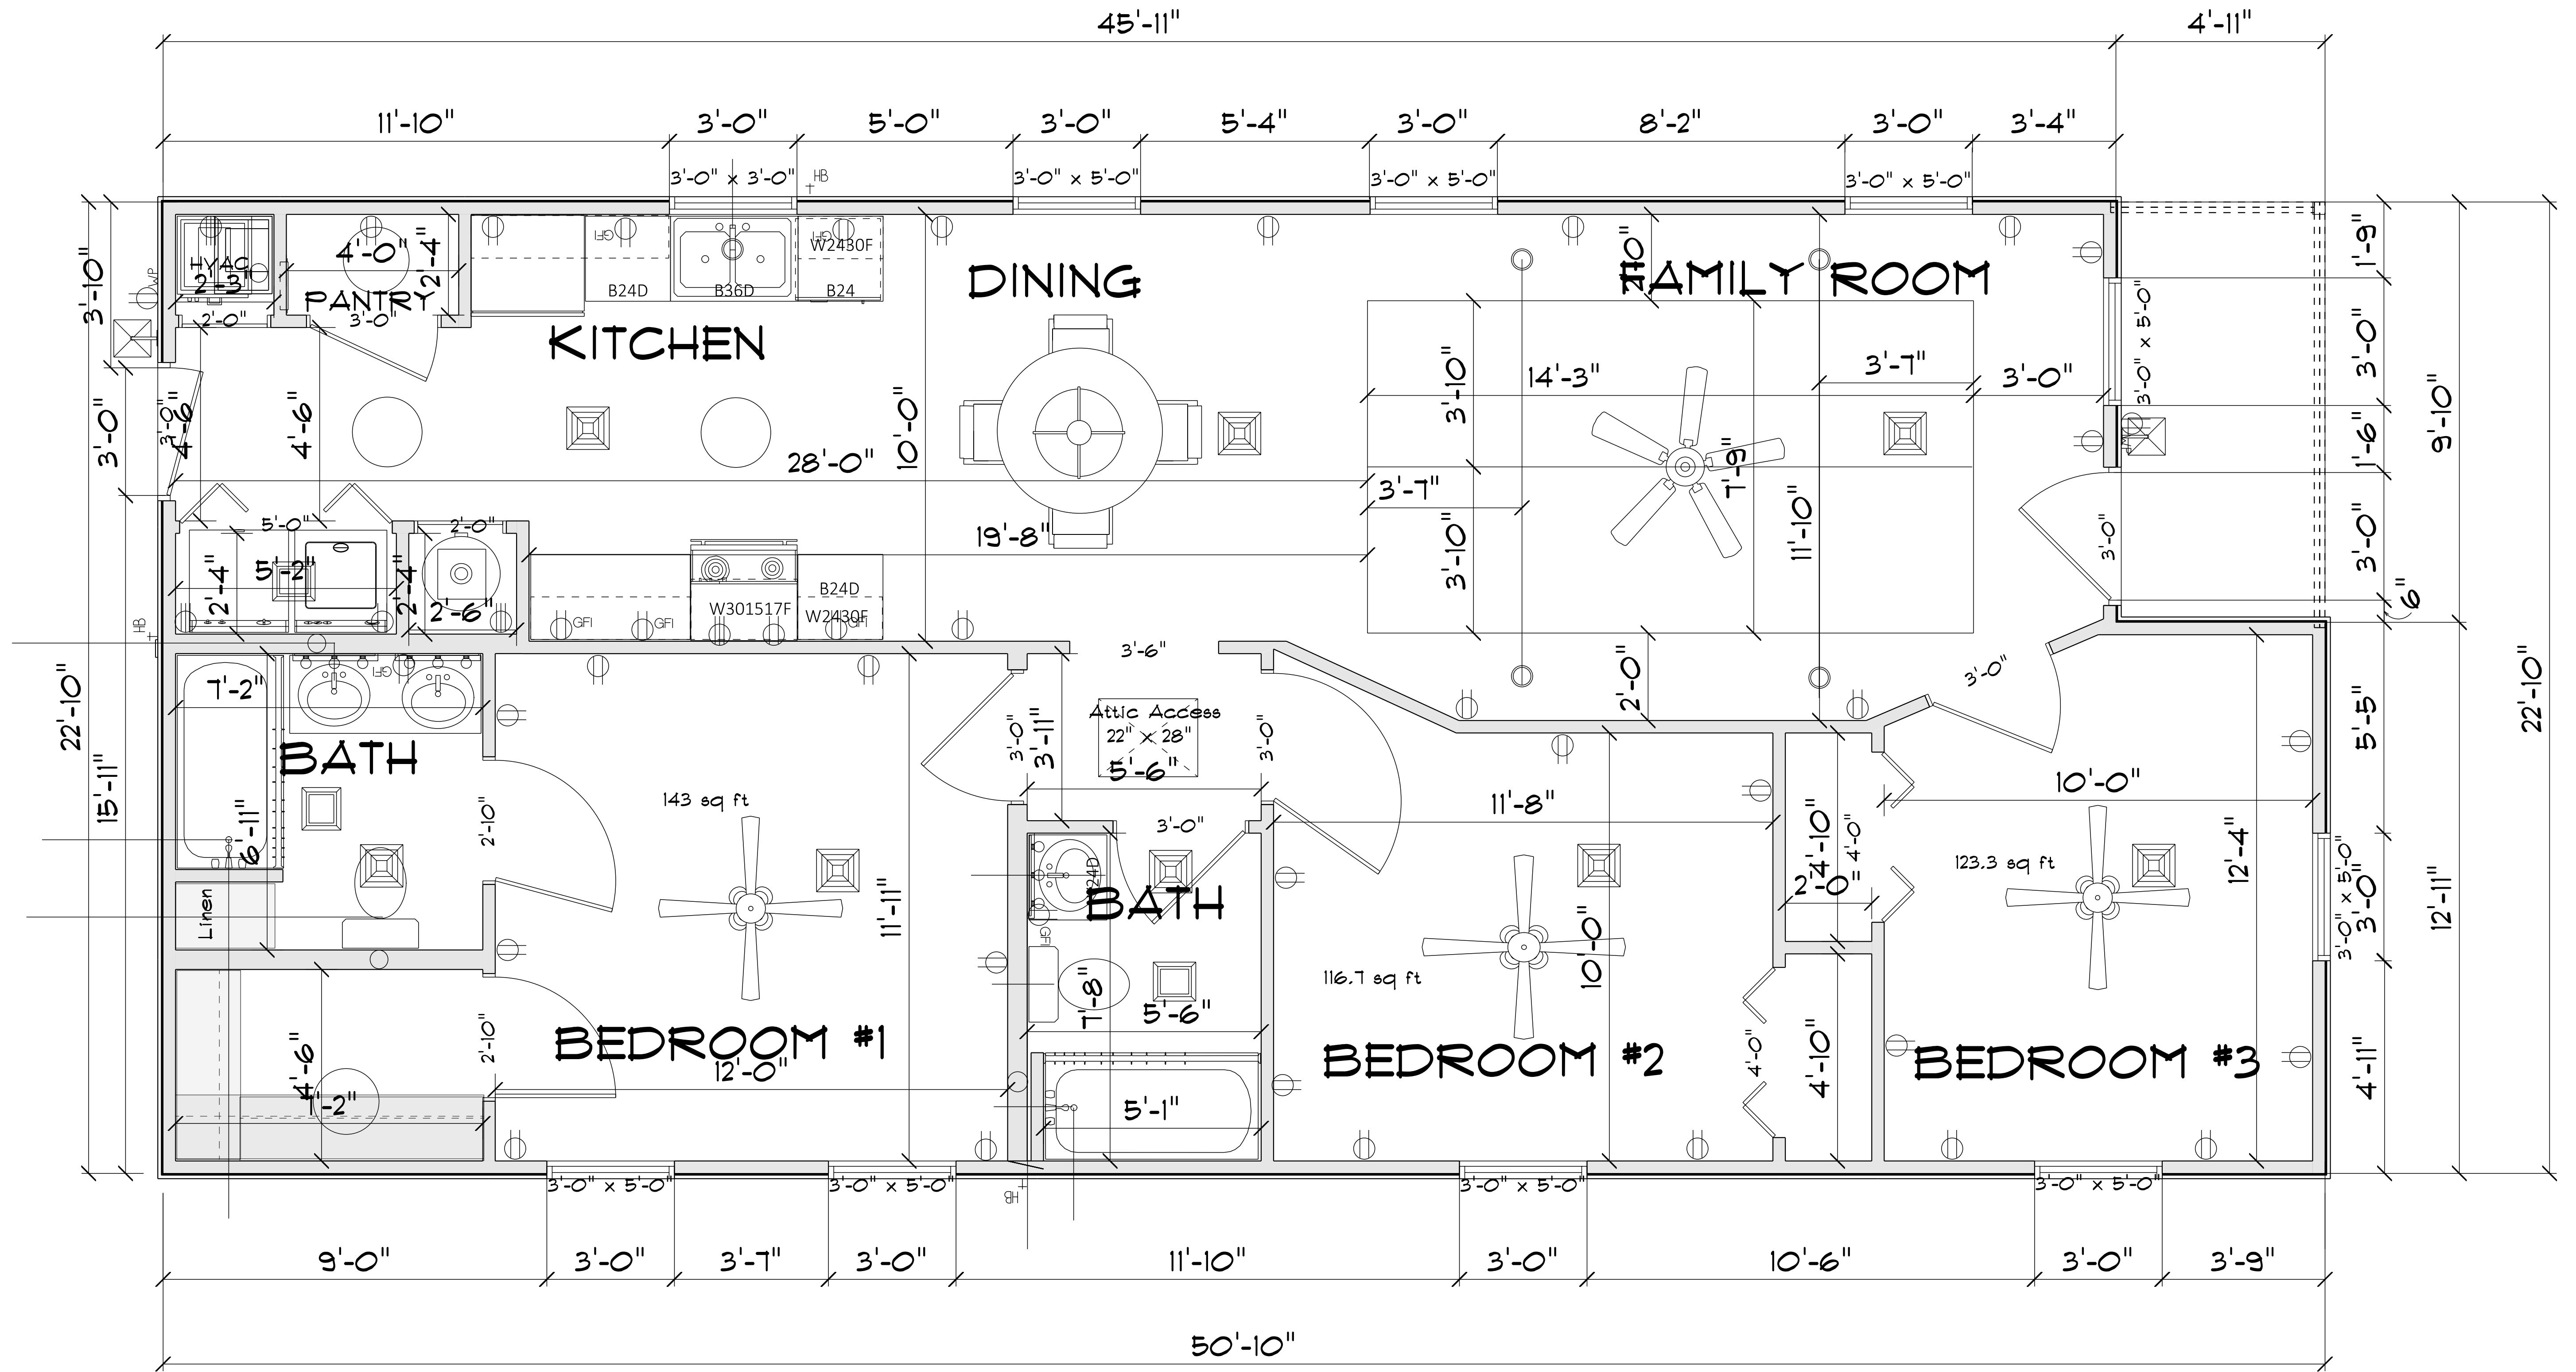

Living 1130 Sq. Ft.
Porch 50 Sq. Ft.

THE SHAWNEE
SCALE: 1/2" = 1'-0"

HVAC
Ceiling Vents
Return Air, Air Handler and Heat Exchange
located in Kitchen next Pantry

NOTE: THESE PLANS ARE NOT DETAILED DOCUMENTS THAT OUTLINE AND DELINEATE ALL ACCEPTED CONSTRUCTION PRACTICES. THE BUILDER MUST HAVE THE FIELD EXPERIENCE AND ABILITY TO SOLVE BUILDING ISSUES AND CONFLICTS. ALL SUBCONTRACTORS SHOULD BE PROFICIENT IN THEIR ABILITY TO INTERPRET PLANS, UNDERSTAND AND FOLLOW CODE REQUIREMENTS AND ACCEPTABLE CONSTRUCTION PRACTICES IN THE CONSTRUCTION PROCESS.

LCJ DESIGN LLC. IS NOT RESPONSIBLE FOR ANY CONSTRUCTION ISSUES NOT DISCUSSED PRIOR TO BEGINNING CONSTRUCTION. DISCOVERY OF ANY, ERRORS OR OMISSIONS IN THESE DOCUMENTS ARE TO BE BROUGHT TO THE IMMEDIATE ATTENTION OF LCJ DESIGN LLC. PRIOR TO ANY CONSTRUCTION WORK OR PURCHASES. ALL DIMENSIONS AND CLEARANCES TO BE VERIFIED BY OWNER/CONTRACTOR PRIOR TO BEGINNING ANY CONSTRUCTION. LCJ DESIGN LLC. IS NOT RESPONSIBLE FOR ANY CONSTRUCTION ISSUES WHICH MAY ARISE DURING OR AFTER THE CONSTRUCTION OF THIS BUILDING. THERE ARE NO GUARANTEES OR WARRANTIES SPECIFIC OR IMPLIED ASSOCIATED WITH THESE DESIGN DOCUMENTS.

DESIGN, LLC.
LCJ Design
5526 N Cleveland Street
Dayton, Texas 77535
PHONE: 936-402-2166
FAX: 639-402-2166
MOBILE: 639-402-2166
jdbrown@lcjdesign.net

SECTION LETTER
A
PAGE NUMBERS
11

All Services Consulting
PHONE:
FAX:
MOBILE:
DRAWN BY:
SCALE: 1/2" = 1'-0"
DATE: Saturday, October 9, 2021
PAGE:
9/11
HVAC




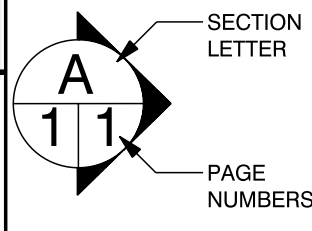
NORTH ELEVATION
SCALE: 3/8" = 1'-0"




SOUTH ELEVATION
SCALE: 3/8" = 1'-0"


NOTE: THESE PLANS ARE NOT DETAILED DOCUMENTS THAT OUTLINE AND DELINEATE ALL ACCEPTED CONSTRUCTION PRACTICES. THE BUILDER MUST HAVE THE FIELD EXPERIENCE AND ABILITY TO SOLVE BUILDING ISSUES AND CONFLICTS. ALL SUBCONTRACTORS SHOULD BE PROFICIENT IN THEIR ABILITY TO INTERPRET PLANS, UNDERSTAND AND FOLLOW CODE REQUIREMENTS AND ACCEPTABLE CONSTRUCTION PRACTICES IN THE CONSTRUCTION PROCESS.

LCJ DESIGN LLC. IS NOT RESPONSIBLE FOR ANY CONSTRUCTION ISSUES NOT DISCUSSED PRIOR TO BEGINNING CONSTRUCTION. DISCOVERY OF ANY, ERRORS OR OMISSIONS IN THESE DOCUMENTS ARE TO BE BROUGHT TO THE IMMEDIATE ATTENTION OF LCJ DESIGN LLC. PRIOR TO ANY CONSTRUCTION WORK OR PURCHASES. ALL DIMENSIONS AND CLEARANCES TO BE VERIFIED BY OWNER/CONTRACTOR PRIOR TO BEGINNING ANY CONSTRUCTION. LCJ DESIGN LLC. IS NOT RESPONSIBLE FOR ANY CONSTRUCTION ISSUES WHICH MAY ARISE DURING OR AFTER THE CONSTRUCTION OF THIS BUILDING. THERE ARE NO GUARANTEES OR WARRANTIES SPECIFIC OR IMPLIED ASSOCIATED WITH THESE DESIGN DOCUMENTS.

 DESIGN, LLC. LCJ Design 5526 N Cleveland Street Dayton, Texas 77535 PHONE: 936-402-2166 FAX: 936-402-2166 MOBILE: 639-402-2166 jdbrown@lcjdesign.net		All Services Consulting PHONE: FAX: MOBILE:	
		DRAWN BY: SCALE: 3/8" = 1'-0" DATE: Saturday, October 9, 2021	PAGE: 10/11 Side Elevations

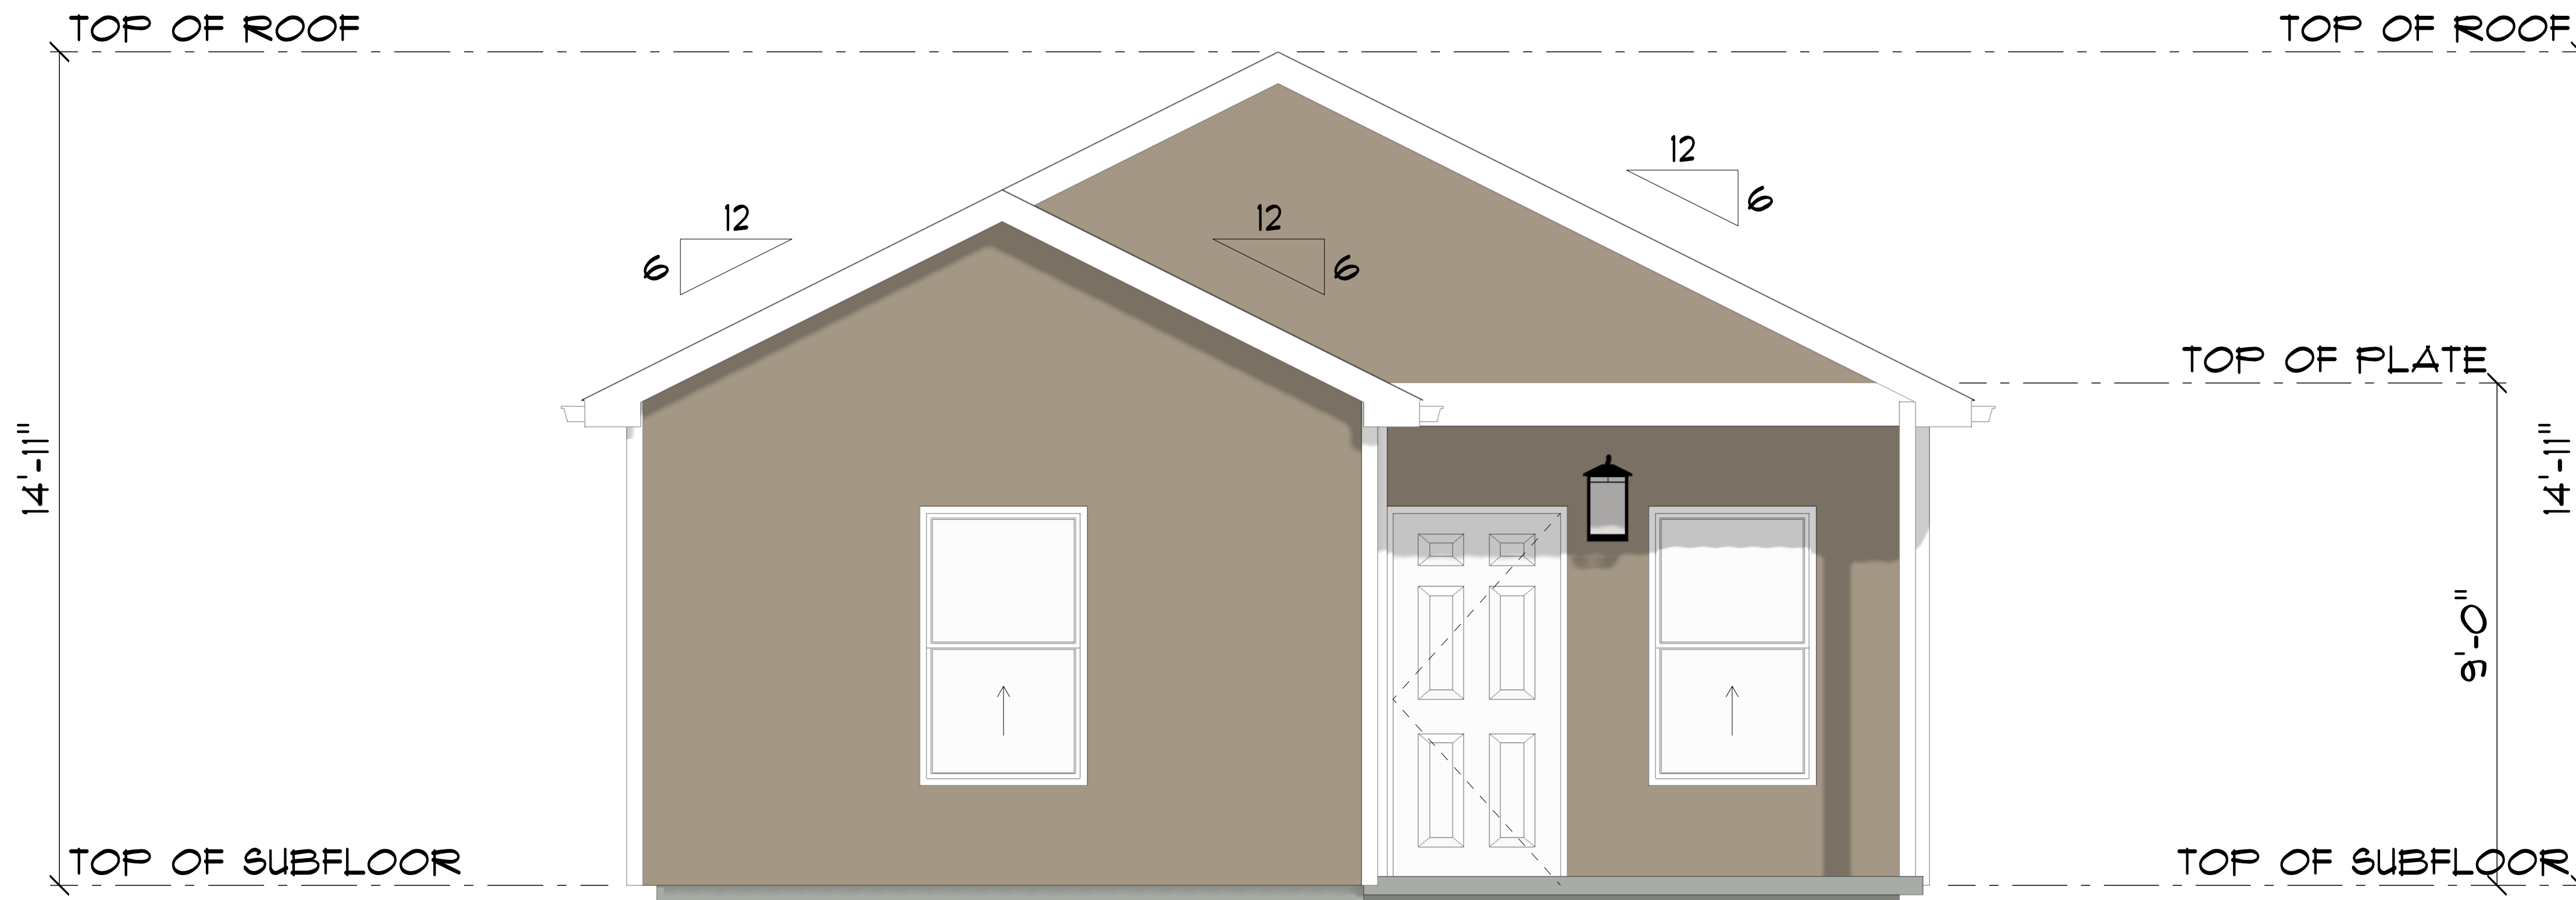


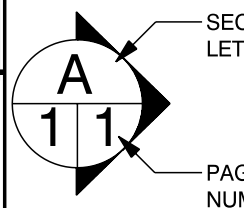
EAST ELEVATION
SCALE: 1/2" = 1'-0"

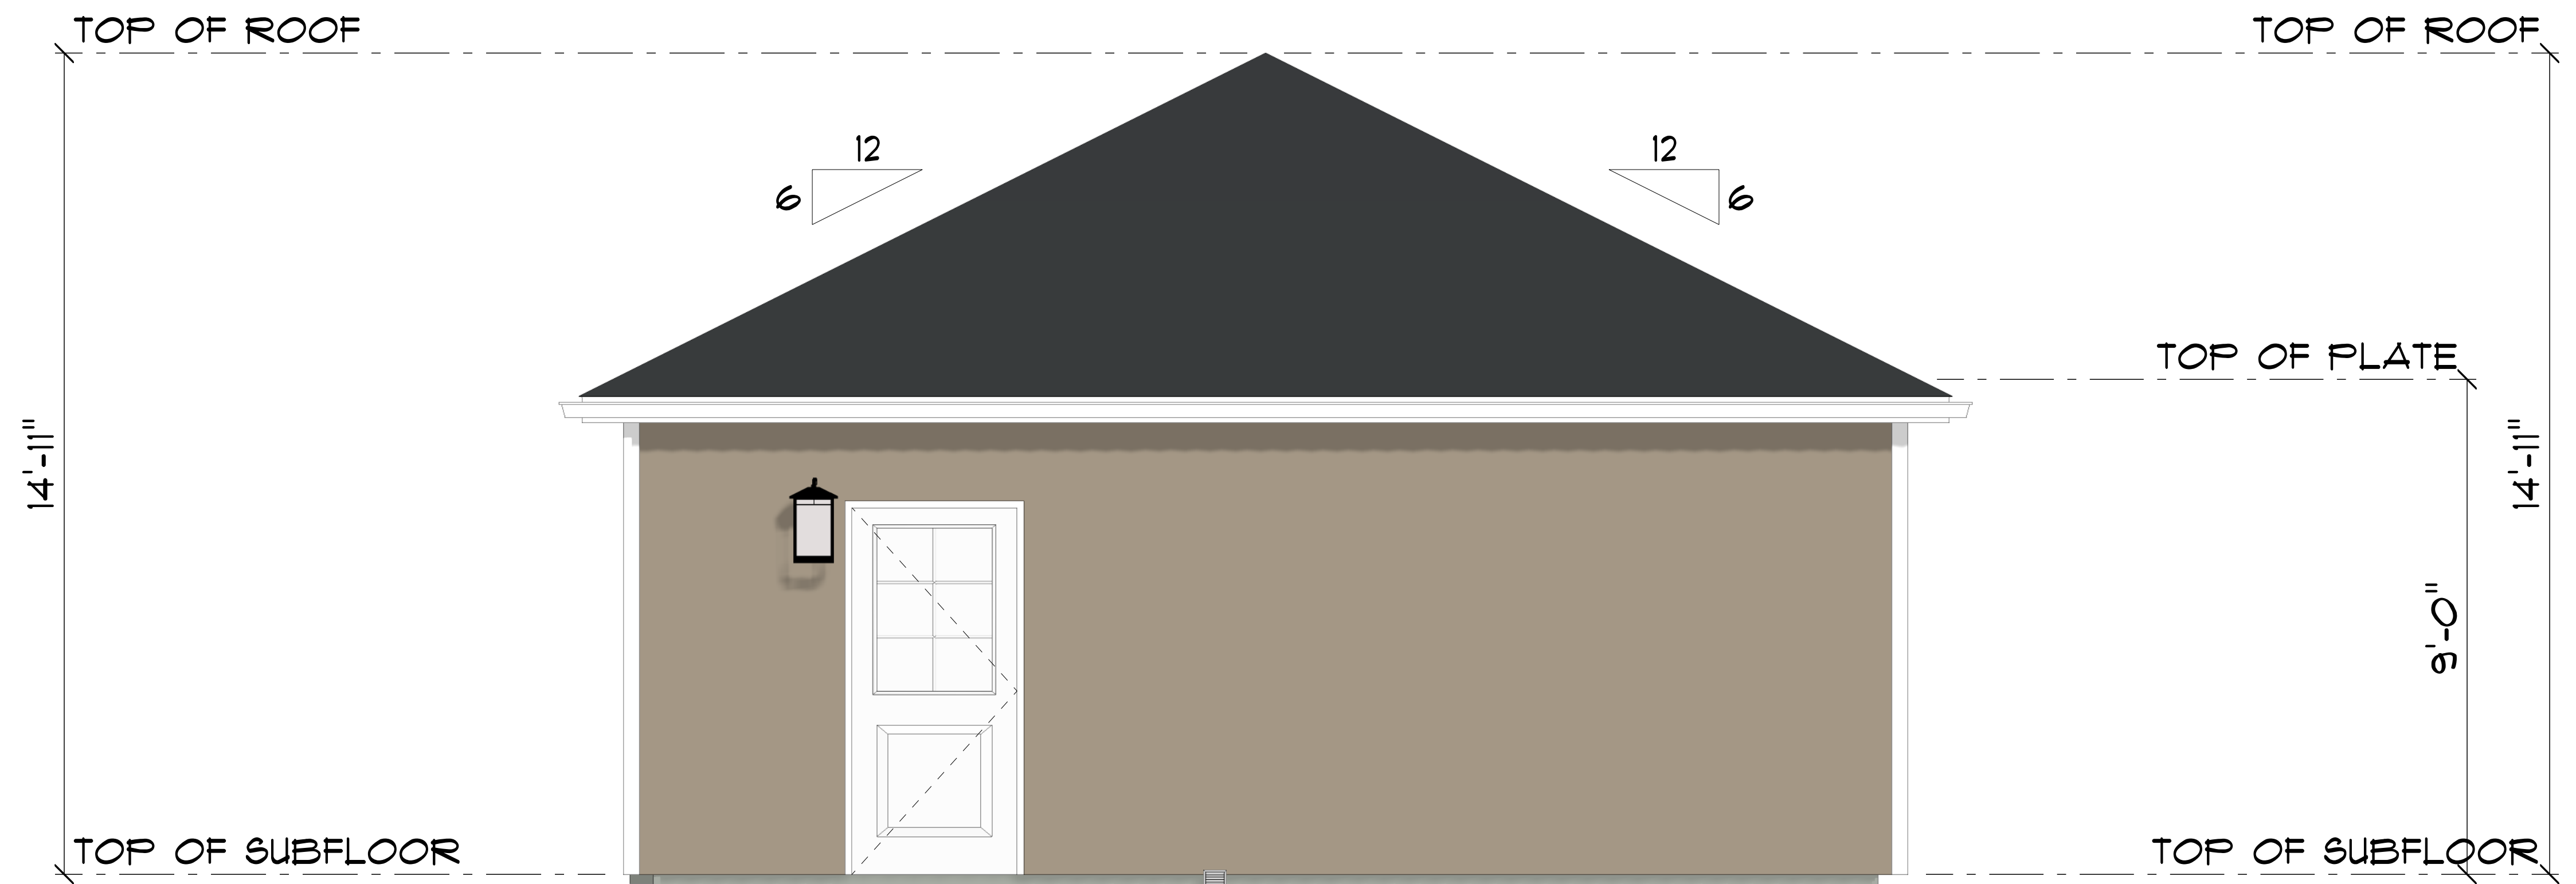

WEST ELEVATION
SCALE: 1/2" = 1'-0"

NOTE: THESE PLANS ARE NOT DETAILED DOCUMENTS THAT OUTLINE AND DELINEATE ALL ACCEPTED CONSTRUCTION PRACTICES. THE BUILDER MUST HAVE THE FIELD EXPERIENCE AND ABILITY TO SOLVE BUILDING ISSUES AND CONFLICTS. ALL SUBCONTRACTORS SHOULD BE PROFICIENT IN THEIR ABILITY TO INTERPRET PLANS, UNDERSTAND AND FOLLOW CODE REQUIREMENTS AND ACCEPTABLE CONSTRUCTION PRACTICES IN THE CONSTRUCTION PROCESS.

LCJ DESIGN LLC. IS NOT RESPONSIBLE FOR ANY CONSTRUCTION ISSUES NOT DISCUSSED PRIOR TO BEGINNING CONSTRUCTION. DISCOVERY OF ANY, ERRORS OR OMISSIONS IN THESE DOCUMENTS ARE TO BE BROUGHT TO THE IMMEDIATE ATTENTION OF LCJ DESIGN LLC. PRIOR TO ANY CONSTRUCTION WORK OR PURCHASES. ALL DIMENSIONS AND CLEARANCES TO BE VERIFIED BY OWNER/CONTRACTOR PRIOR TO BEGINNING ANY CONSTRUCTION. LCJ DESIGN LLC. IS NOT RESPONSIBLE FOR ANY CONSTRUCTION ISSUES WHICH MAY ARISE DURING OR AFTER THE CONSTRUCTION OF THIS BUILDING. THERE ARE NO GUARANTEES OR WARRANTIES SPECIFIC OR IMPLIED ASSOCIATED WITH THESE DESIGN DOCUMENTS.

 DESIGN, LLC. LCJ Design 5526 N Cleveland Street Dayton, Texas 77535 PHONE: 936-402-2166 FAX: 936-402-2166 MOBILE: 639-402-2166 jdbrown@lcjdesign.net	 SECTION LETTER PAGE NUMBERS	All Services Consulting PHONE: FAX: MOBILE:	
		DRAWN BY: SCALE: 1/2" = 1'-0" DATE: Saturday, October 5, 2019	PAGE: 11/11 and Rear Elevations